


Section 4
SPECIALIST REPORTS



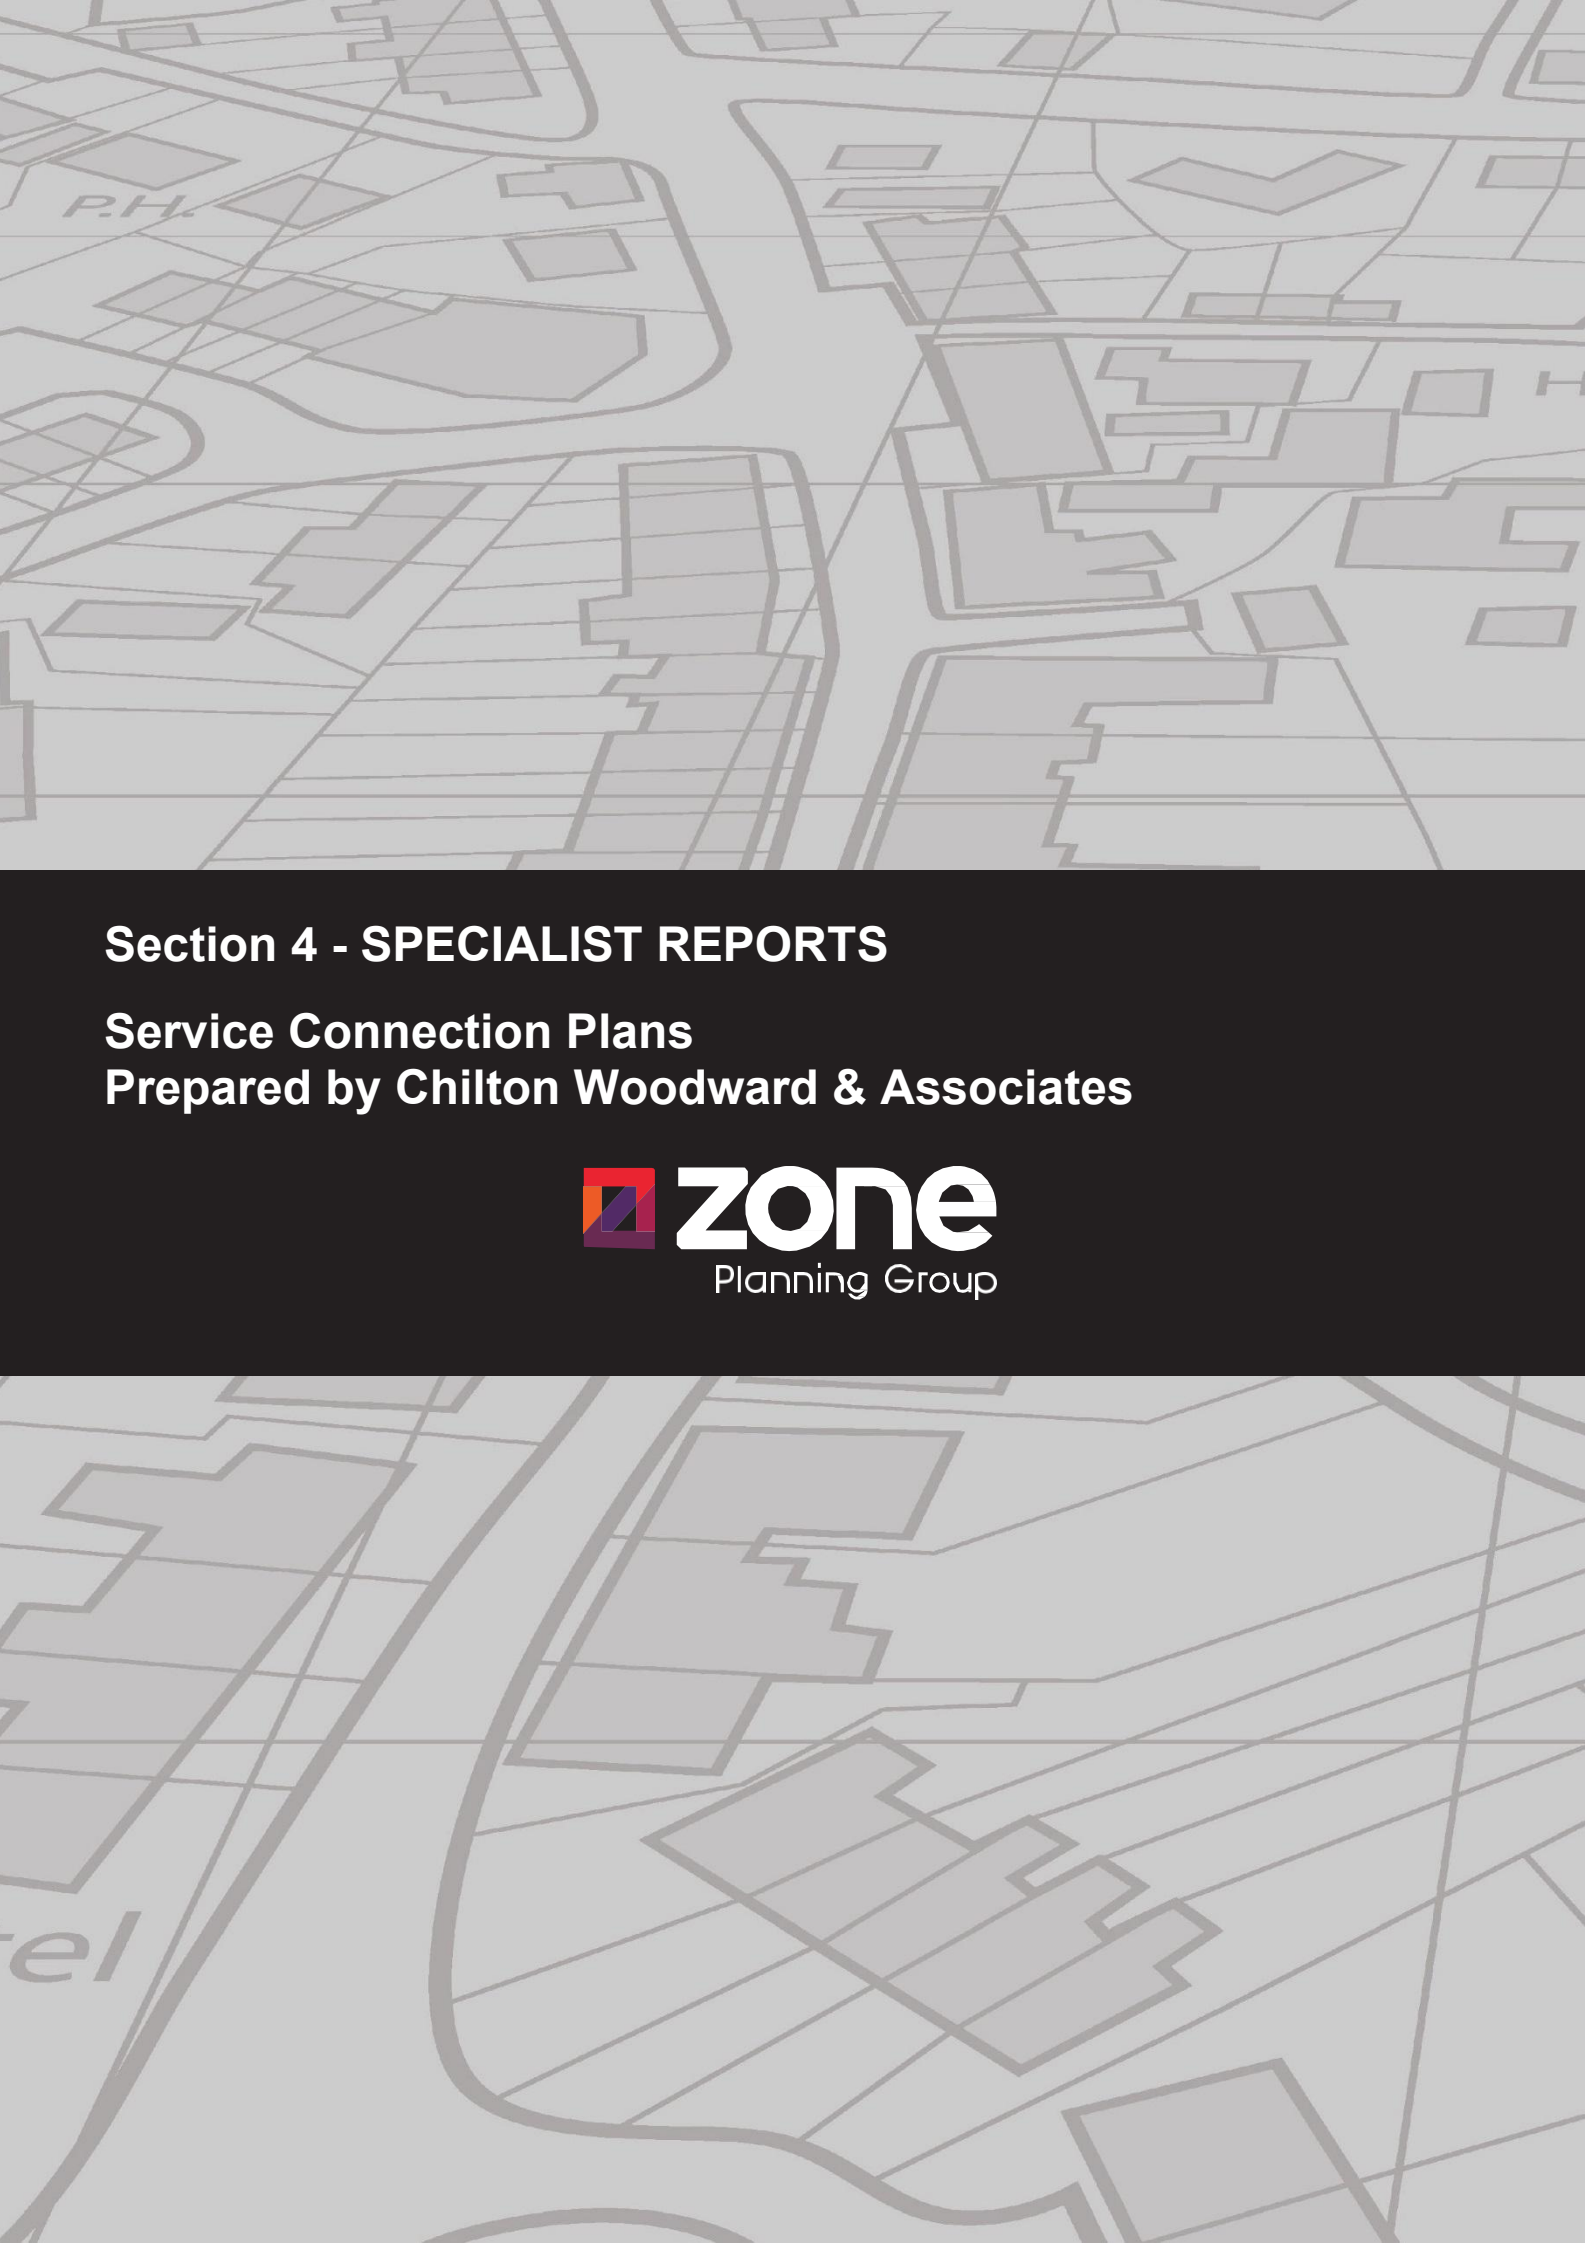


Section 4 - SPECIALIST REPORTS

Service Connection Plans

Prepared by Chilton Woodward & Associates





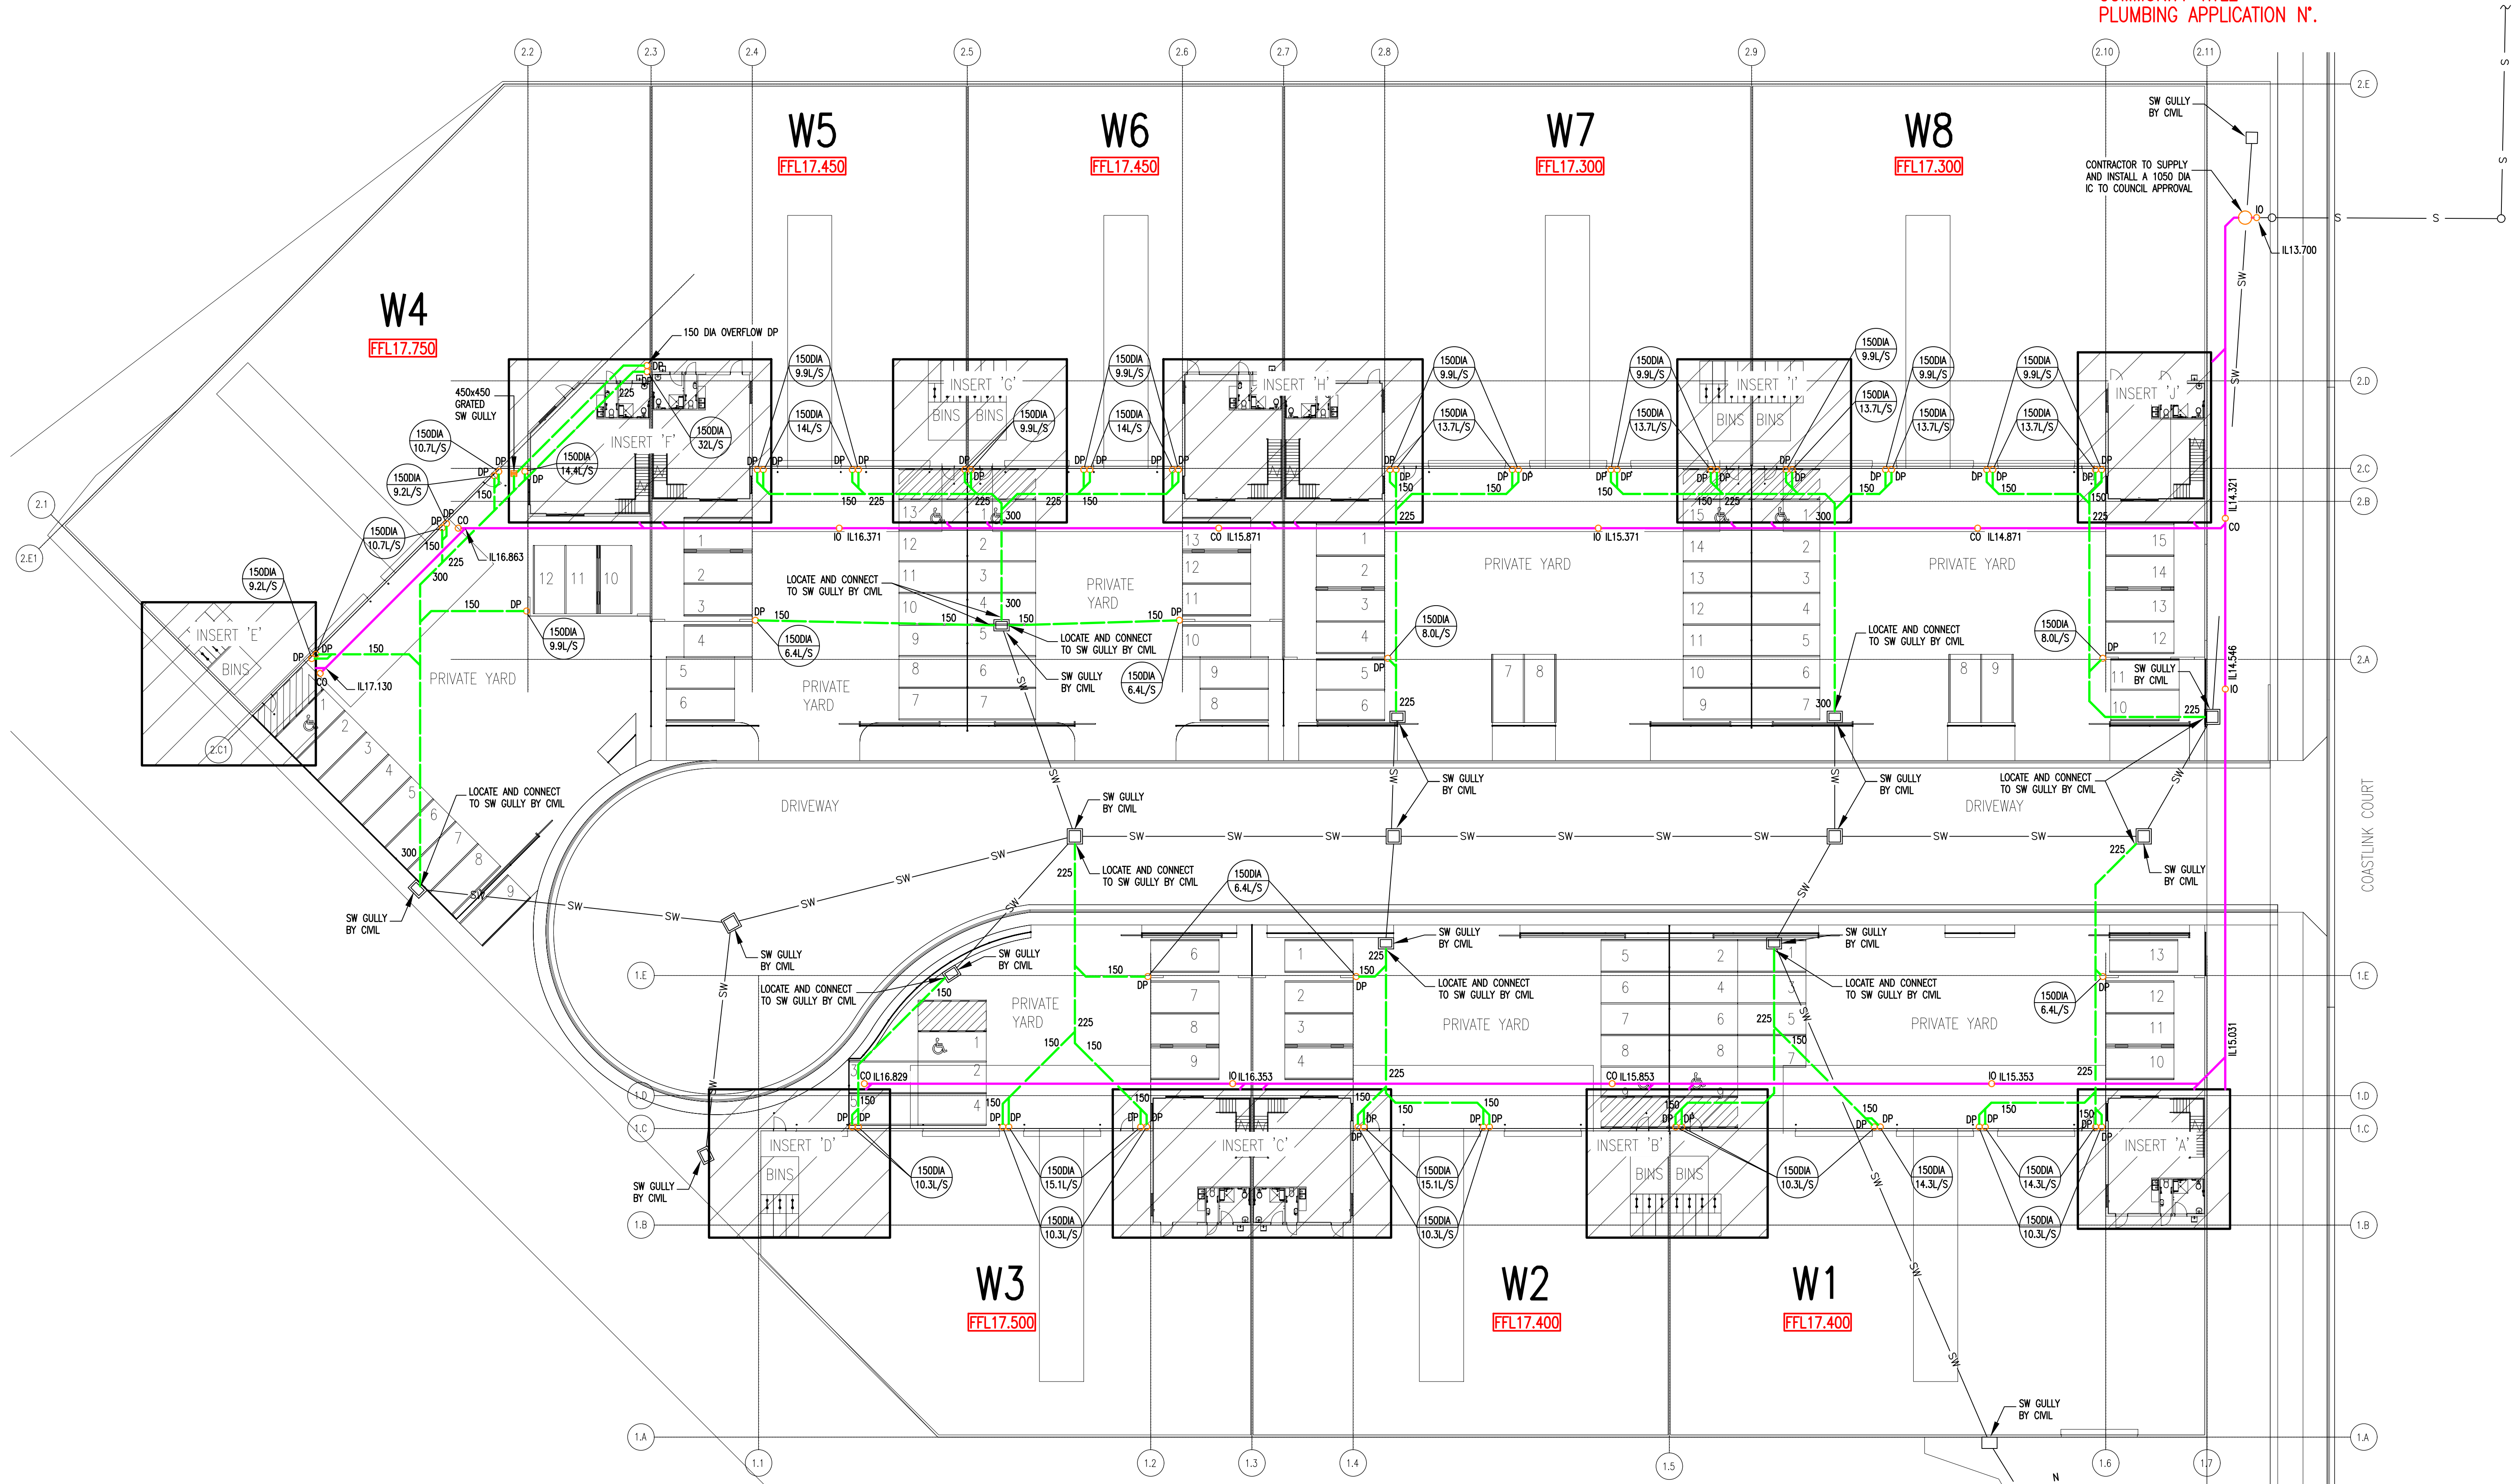

NOT FOR CONSTRUCTION

SANITARY AND STORMWATER SERVICES
SITE AND GROUND FLOOR PLAN
SCALE 1:250

THIS DRAWING HAS BEEN
PREPARED IN ACCORDANCE
WITH AS/NZS 3500 AND UNDER
QBCC DESIGN LICENSE 1066809
CWA BUILDING HYDRAULIC &
FIRE SERVICES PTY LTD
ACN 112305772

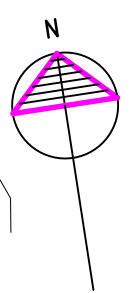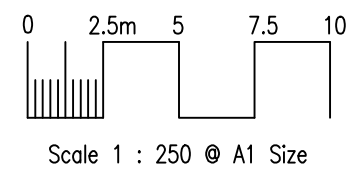

A	ISSUE FOR COUNCIL SUBMISSION	DEC'25	MRB
ISSUE	DESCRIPTION	DATE	CAD

OWNER
CARMDEV

ARCHITECT
ATP DESIGN STUDIO
6/3900 PACIFIC HIGHWAY, LOGANHOLME QLD 4129
PHONE: 0423 535 120

PROJECT
PROPOSED 8 WAREHOUSES
AT LOT 303 COASTLINK CRT
STAPYLTON QLD 4207
R.P.D LOT 506 ON SP329487


**Chilton Woodward
& Associates**
Hydraulic & Fire Service Consultants
Suite 16, Argyle Place
14 Argyle Street, Albion 4010
Email: office@cwhhyd.com.au

CWA
QBCC N.1066809
ABN 79 112 305 772
PH: (07) 3282 4322

DESIGNER	CAD	CHECKED	SCALE	DATE
V.Cross	STL	WC ?	1:250	Oct'25

DRAWING TITLE
HYDRAULIC SERVICES
SANITARY & STORMWATER SERVICES
SITE AND GROUND FLOOR PLAN



DRAWING No.
25488-H3
SHEET No.
3 of 13

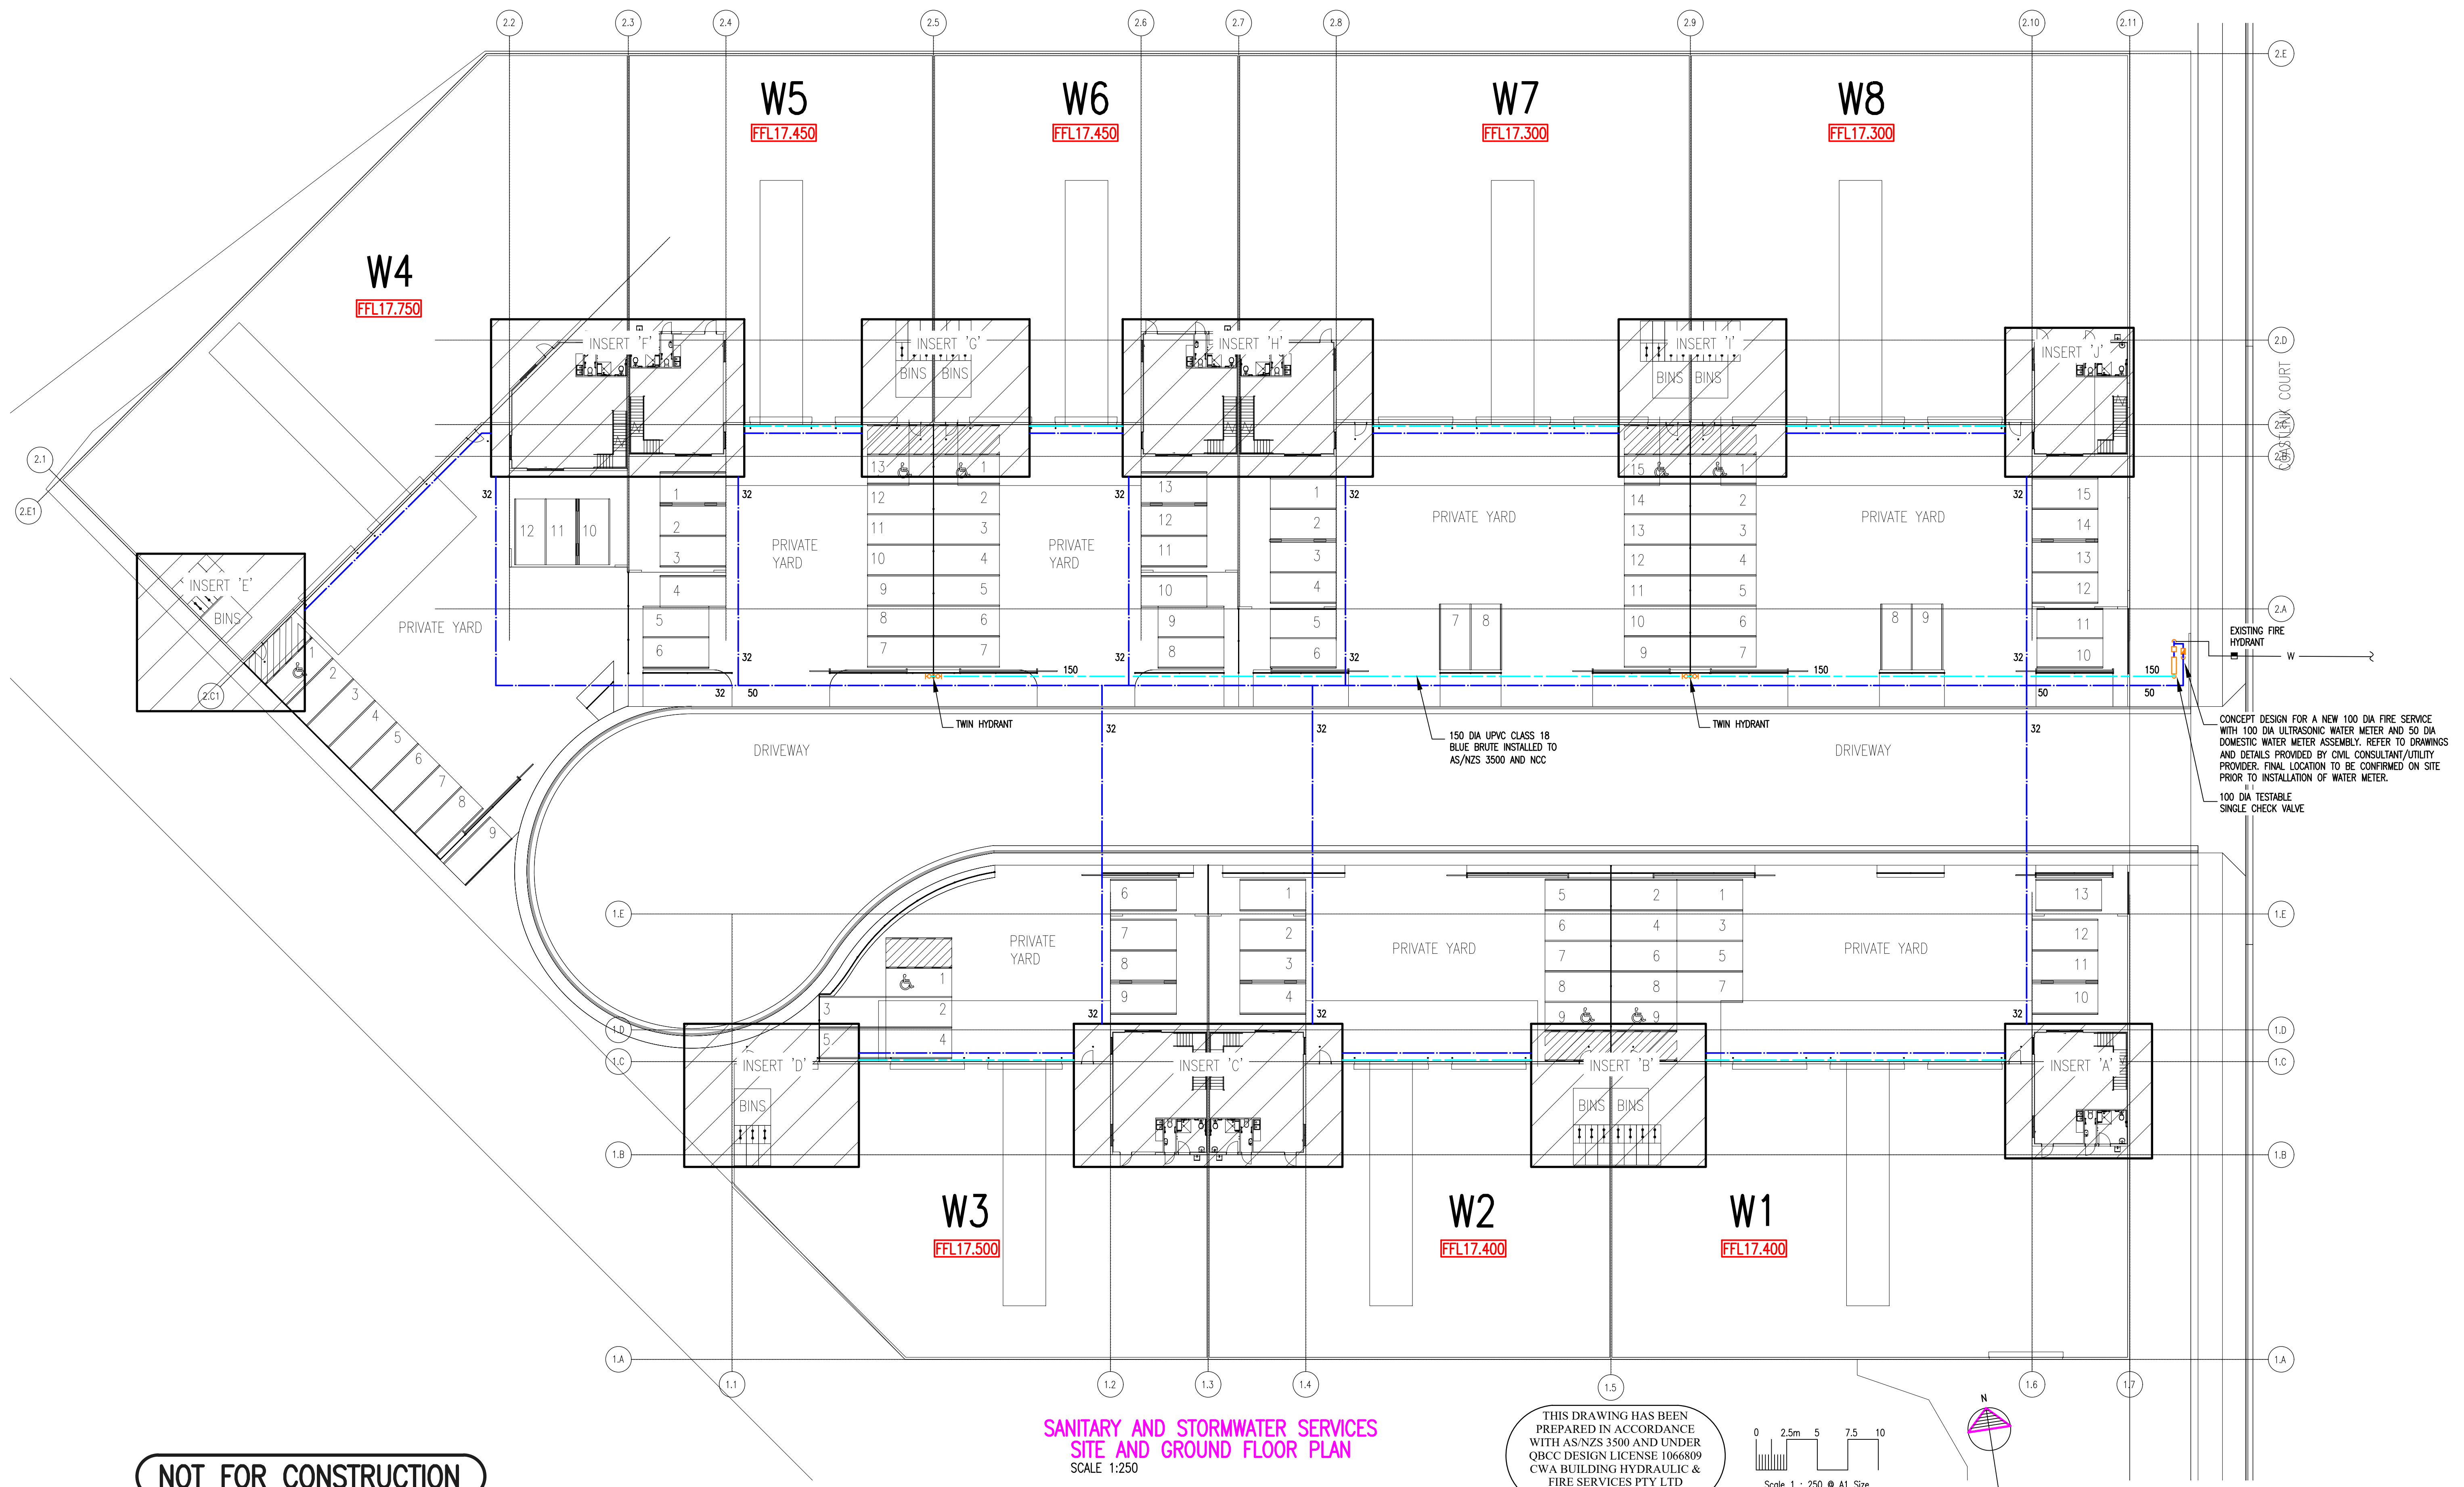

NOT FOR CONSTRUCTION

SANITARY AND STORMWATER SERVICES
SITE AND GROUND FLOOR PLAN
SCALE 1:250

THIS DRAWING HAS BEEN
PREPARED IN ACCORDANCE
WITH AS/NZS 3500 AND UNDER
QBCC DESIGN LICENSE 1066809
CWA BUILDING HYDRAULIC &
FIRE SERVICES PTY LTD
ACN 112305772

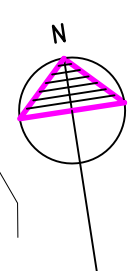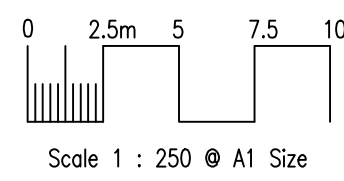

A	ISSUE FOR COUNCIL SUBMISSION	DEC'25	MRB
ISSUE	DESCRIPTION	DATE	CAD

OWNER
CARMDEV

ARCHITECT
ATP DESIGN STUDIO
6/3900 PACIFIC HIGHWAY, LOGANHOLME QLD 4129
PHONE: 0423 535 120

PROJECT
PROPOSED 8 WAREHOUSES
AT LOT 303 COASTLINK CRT
STAPYLTON QLD 4207

R.P.D LOT 506 ON SP329487

**Chilton Woodward
& Associates**
Hydraulic & Fire Service Consultants
Suite 16, Argyle Place
14 Argyle Street, Albion 4010
Email: office@cwhhyd.com.au

CWA
QBCC N.1066809
ABN 79 112 305 772
PH: (07) 3282 4322

DESIGNER	CAD	CHECKED	SCALE	DATE
V.Cross	STL	W.C. ?	1:250	Oct'25

DRAWING TITLE
HYDRAULIC SERVICES
FIRE & WATER SERVICES
SITE AND GROUND FLOOR PLAN

DRAWING No.
25488-H9

SHEET No.
9 of 13