

DOCUMENT TRANSMITTAL SCHEDULE

To: City of Gold Coast Council

Address : PO Box 5042
GCMC 9726

Attention: Development Assessment

PROJECT: OPERATIONAL WORKS APPLICATION FOR CIVIL WORKS
STAGE 1 VANTAGE YATALA (INDUSTRIAL DEVELOPMENT) Job No: 5941

The documents listed below are issued for your use as indicated in the "Issued for" section.

All revisions supersede any revision of the same document.

DATE OF ISSUE	Day	28	12	27	30	05	21	24	26	24	07	31	10
	Month	10	03	04	04	05	05	05	05	06	07	08	09
	Year	20	21	21	21	21	21	21	21	21	21	21	21

Distribution:

Attention	Issued To												
City of Gold Coast Council	Development Assesment		1xPDF	1xPDF	1xPDF	1xPDF	1xPDF	1xPDF	1xPDF				1xPDF
FRASERS PROPERTY (AUSTRALIA) PTY. LTD	Commercial and Industrial	1xPDF											
SEE Civil	Leanne Shea - Project Manager									1xPDF	1xPDF	1xPDF	

Method:

- ☐ Our Mess.
- ☐ Your Mess.
- ☐ Hand
- ☐ Courier
- ☐ Mail
- ☒ FTP Site
- ☐ Email
- ☐ Aconex

C	A	A	A	A	A	A	A	C	C	C	A
C - Construction				T -Tender							
I - Information				O - Other							

The information in any Gassman Development Perspectives generated messages together with any attachments is intended only for the person or entity to which it is addressed and may contain confidential and/or privileged material. Any form of review, disclosure, modification, distribution and/or publication of this message is prohibited. If you have received this message in error, you are asked to inform the sender as quickly as possible and delete this message and any copies of this message from your computer and/or your computer system network.In relation to computer viruses, any loss or damage incurred by using this material is not the responsibility of the sender. The sending company's entire liability will be limited to resupplying the material. No warranty is made that this material is free from computer virus or other defect. Please consider the environment before printing any electronic media received from Gassman Development Perspectives.

EP	EP	EP	EP	EP	EP	EP	EP	EP	EP	EP	EP
P Print				CP -CAD&PDF							
EP - PDF											

Drg/Doc No.	Title												
5941 ENG OPW1 001	DRAWING INDEX AND LOCALITY PLAN	F	G	H	-	-	-	-	-	-	H	I	J
5941 ENG OPW1 002	GENERAL NOTES SHEET 1 OF 3	B	-	-	-	-	-	-	-	-	-	-	-
5941 ENG OPW1 003	GENERAL NOTES SHEET 2 OF 3	B	-	-	-	-	-	-	-	-	-	-	-
5941 ENG OPW1 003	GENERAL NOTES SHEET 3 OF 3	B	-	-	-	-	-	-	-	-	-	-	-
5941 ENG OPW1 005	LEGEND	B	C	-	-	-	-	-	-	-	-	-	-
5941 ENG OPW1 006	KEY PLAN LAYOUT	C	-	D	-	-	-	-	-	-	D	-	-
5941 ENG OPW1 010	EXISTING SURFACE AND FEATURE PLAN	B	-	-	-	-	-	-	-	-	-	-	-
5941 ENG OPW1 020	EMERI STREET DEMOLITION AND PROTECTION LAYOUT PLAN	B	-	-	-	-	-	-	-	-	-	-	-
5941 ENG OPW1 050	SEDIMENT AND EROSION CONTROL PLAN SHEET 1 OF 6	C	D	-	-	-	-	-	-	-	-	-	-
5941 ENG OPW1 051	SEDIMENT AND EROSION CONTROL PLAN SHEET 2 OF 6	B	-	-	-	-	-	-	-	-	-	-	-
5941 ENG OPW1 052	SEDIMENT AND EROSION CONTROL PLAN SHEET 3 OF 6	C	-	-	-	-	-	-	-	-	-	-	-
5941 ENG OPW1 053	SEDIMENT AND EROSION CONTROL PLAN SHEET 4 OF 6	C	-	D	-	-	-	-	-	-	D	-	-
5941 ENG OPW1 054	SEDIMENT AND EROSION CONTROL PLAN SHEET 5 OF 6	C	-	-	-	-	-	-	-	-	-	-	-
5941 ENG OPW1 055	SEDIMENT AND EROSION CONTROL PLAN SHEET 6 OF 6	C	-	-	-	-	-	-	-	-	-	-	-
5941 ENG OPW1 056	CONSTRUCTION PHASE SEDIMENT BASIN 1 LAYOUT	C	D	-	-	-	-	-	-	-	-	-	-
5941 ENG OPW1 057	CONSTRUCTION PHASE SEDIMENT BASIN 1 SECTIONS	B	-	-	-	-	-	-	-	-	-	-	-
5941 ENG OPW1 058	CONSTRUCTION PHASE SEDIMENT BASIN 2 LAYOUT	B	-	-	-	-	-	-	-	-	-	-	-
5941 ENG OPW1 059	CONSTRUCTION PHASE SEDIMENT BASIN 2 SECTIONS	B	-	-	-	-	-	-	-	-	-	-	-
5941 ENG OPW1 060	SEDIMENT AND EROSION TYPICAL DETAILS	B	-	-	-	-	-	-	-	-	-	-	-
5941 ENG OPW1 300	OVERALL SERVICES LAYOUT PLAN SHEET 1 OF 4	C	D	-	-	-	-	-	-	-	-	-	-
5941 ENG OPW1 301	OVERALL SERVICES LAYOUT PLAN SHEET 2 OF 4	C	-	D	-	-	-	-	-	-	D	-	-
5941 ENG OPW1 302	OVERALL SERVICES LAYOUT PLAN SHEET 3 OF 4	C	-	-	-	-	-	-	-	-	-	-	-
5941 ENG OPW1 303	OVERALL SERVICES LAYOUT PLAN SHEET 4 OF 4	C	-	-	-	-	-	-	-	-	-	-	-
5941 ENG OPW1 400	ROADWORKS AND DRAINAGE LAYOUT PLAN SHEET 1 OF 4	C	D	-	-	-	-	-	-	-	-	-	-
5941 ENG OPW1 401	ROADWORKS AND DRAINAGE LAYOUT PLAN SHEET 2 OF 4	C	-	D	-	-	-	-	-	-	D	-	-
5941 ENG OPW1 402	ROADWORKS AND DRAINAGE LAYOUT PLAN SHEET 3 OF 4	C	-	-	-	-	-	-	-	-	-	-	-
5941 ENG OPW1 403	ROADWORKS AND DRAINAGE LAYOUT PLAN SHEET 4 OF 4	C	-	-	-	-	-	-	-	-	-	-	-
5941 ENG OPW1 410	TYPICAL SECTIONS AND DETAILS SHEET 1 OF 3	C	-	-	-	-	-	-	-	-	-	-	-
5941 ENG OPW1 411	TYPICAL SECTIONS AND DETAILS SHEET 2 OF 3	C	-	-	-	-	-	-	-	-	-	-	-
5941 ENG OPW1 412	TYPICAL SECTIONS AND DETAILS SHEET 3 OF 3	B	-	-	C	-	-	-	-	-	-	-	-
5941 ENG OPW1 420	CONTROL LINE LAYOUT PLAN	C	D	E	-	-	-	-	-	-	E	-	-
5941 ENG OPW1 421	ROAD CONTROL LINE SETOUT TABLES SHEET 1 OF 2	C	-	D	-	-	-	-	-	-	D	-	-
5941 ENG OPW1 422	ROAD CONTROL LINE SETOUT TABLES SHEET 2 OF 2	C	-	D	-	-	-	-	-	-	D	-	-
5941 ENG OPW1 430	ROAD LONGITUDINAL SECTION - HOMESTEAD DRIVE SHEET 1 OF 3	C	D	-	-	-	-	-	-	-	-	-	-
5941 ENG OPW1 431	ROAD LONGITUDINAL SECTION - HOMESTEAD DRIVE SHEET 2 OF 3	C	-	-	-	-	-	-	-	-	-	-	-
5941 ENG OPW1 432	ROAD LONGITUDINAL SECTION - HOMESTEAD DRIVE SHEET 3 OF 3	C	-	-	-	-	-	-	-	-	-	-	-
5941 ENG OPW1 433	ROAD LONGITUDINAL SECTION - EASTRIDGE STREET SHEET 1 OF 2	C	-	-	-	-	-	-	-	-	-	-	-
5941 ENG OPW1 434	ROAD LONGITUDINAL SECTION - EASTRIDGE STREET SHEET 2 OF 2	C	-	-	-	-	-	-	-	-	-	-	-
5941 ENG OPW1 435	ROAD LONGITUDINAL SECTION - FAIRWAY STREET SHEET 1 OF 2	C	-	D	-	-	-	-	-	-	D	-	-
5941 ENG OPW1 436	ROAD LONGITUDINAL SECTION - FAIRWAY STREET SHEET 2 OF 2	C	-	-	-	-	-	-	-	-	-	-	-
5941 ENG OPW1 437	ROAD LONGITUDINAL SECTION - EMERI STREET EXTENSION	B	-	-	-	-	-	-	-	-	-	-	-
5941 ENG OPW1 450	ROAD CROSS SECTIONS - HOMESTEAD DRIVE SHEET 1 OF 14	C	D	-	-	-	-	-	-	-	-	-	-
5941 ENG OPW1 451	ROAD CROSS SECTIONS - HOMESTEAD DRIVE SHEET 2 OF 14	C	-	-	-	-	-	-	-	-	-	-	-
5941 ENG OPW1 452	ROAD CROSS SECTIONS - HOMESTEAD DRIVE SHEET 3 OF 14	C	-	-	-	-	-	-	-	-	-	-	-
5941 ENG OPW1 453	ROAD CROSS SECTIONS - HOMESTEAD DRIVE SHEET 4 OF 14	C	-	-	-	-	-	-	-	-	-	-	-
5941 ENG OPW1 454	ROAD CROSS SECTIONS - HOMESTEAD DRIVE SHEET 5 OF 14	C	-	-	-	-	-	-	-	-	-	-	-

DOCUMENT TRANSMITTAL SCHEDULE

To: City of Gold Coast Council

Address : PO Box 5042
GCMC 9726

Attention: Development Assessment



PROJECT: OPERATIONAL WORKS APPLICATION FOR CIVIL WORKS
STAGE 1 VANTAGE YATALA (INDUSTRIAL DEVELOPMENT) Job No: 5941

The documents listed below are issued for your use as indicated in the "Issued for" section.
All revisions supersede any revision of the same document.

DATE OF ISSUE	Day	28	12	27	30	05	21	24	26	24	07	31	10
	Month	10	03	04	04	05	05	05	05	06	07	08	09
	Year	20	21	21	21	21	21	21	21	21	21	21	21

Distribution:

Attention	Issued To												
City of Gold Coast Council	Development Assesment		1xPDF	1xPDF	1xPDF	1xPDF	1xPDF	1xPDF	1xPDF				1xPDF
FRASERS PROPERTY (AUSTRALIA) PTY. LTD	Commercial and Industrial	1xPDF											
SEE Civil	Leanne Shea - Project Manager									1xPDF	1xPDF	1xPDF	

Method:

- ☐ Our Mess.
- ☐ Your Mess.
- ☐ Hand
- ☐ Courier
- ☐ Mail
- ☒ FTP Site
- ☐ Email
- ☐ Aconex

C	A	A	A	A	A	A	A	C	C	C	A
C - Construction				T -Tender							
I - Information				O - Other							

The information in any Gassman Development Perspectives generated messages together with any attachments is intended only for the person or entity to which it is addressed and may contain confidential and/or privileged material. Any form of review, disclosure, modification, distribution and/or publication of this message is prohibited. If you have received this message in error, you are asked to inform the sender as quickly as possible and delete this message and any copies of this message from your computer and/or your computer system network.In relation to computer viruses, any loss or damage incurred by using this material is not the responsibility of the sender. The sending company's entire liability will be limited to resupplying the material. No warranty is made that this material is free from computer virus or other defect. Please consider the environment before printing any electronic media received from Gassman Development Perspectives.

EP	EP	EP	EP	EP	EP	EP	EP	EP	EP	EP	EP
P Print				CP -CAD&PDF							
EP - PDF											

Drg/Doc No.	Title												
5941 ENG OPW1 455	ROAD CROSS SECTIONS - HOMESTEAD DRIVE SHEET 6 OF 14	C	-	-	-	-	-	-	-	-	-	-	-
5941 ENG OPW1 456	ROAD CROSS SECTIONS - HOMESTEAD DRIVE SHEET 7 OF 14	C	-	-	-	-	-	-	-	-	-	-	-
5941 ENG OPW1 457	ROAD CROSS SECTIONS - HOMESTEAD DRIVE SHEET 8 OF 14	C	-	-	-	-	-	-	-	-	-	-	-
5941 ENG OPW1 458	ROAD CROSS SECTIONS - HOMESTEAD DRIVE SHEET 9 OF 14	C	-	-	-	-	-	-	-	-	-	-	-
5941 ENG OPW1 459	ROAD CROSS SECTIONS - HOMESTEAD DRIVE SHEET 10 OF 14	C	-	-	-	-	-	-	-	-	-	-	-
5941 ENG OPW1 460	ROAD CROSS SECTIONS - HOMESTEAD DRIVE SHEET 11 OF 14	C	-	-	-	-	-	-	-	-	-	-	-
5941 ENG OPW1 461	ROAD CROSS SECTIONS - HOMESTEAD DRIVE SHEET 12 OF 14	C	-	-	-	-	-	-	-	-	-	-	-
5941 ENG OPW1 462	ROAD CROSS SECTIONS - HOMESTEAD DRIVE SHEET 13 OF 14	C	-	-	-	-	-	-	-	-	-	-	-
5941 ENG OPW1 463	ROAD CROSS SECTIONS - HOMESTEAD DRIVE SHEET 14 OF 14	C	-	-	-	-	-	-	-	-	-	-	-
5941 ENG OPW1 464	ROAD CROSS SECTIONS - EASTRIDGE STREET SHEET 1 OF 8	B	-	-	-	-	-	-	-	-	-	-	-
5941 ENG OPW1 465	ROAD CROSS SECTIONS - EASTRIDGE STREET SHEET 2 OF 8	B	-	-	-	-	-	-	-	-	-	-	-
5941 ENG OPW1 466	ROAD CROSS SECTIONS - EASTRIDGE STREET SHEET 3 OF 8	B	-	-	-	-	-	-	-	-	-	-	-
5941 ENG OPW1 467	ROAD CROSS SECTIONS - EASTRIDGE STREET SHEET 4 OF 8	B	-	-	-	-	-	-	-	-	-	-	-
5941 ENG OPW1 468	ROAD CROSS SECTIONS - EASTRIDGE STREET SHEET 5 OF 8	B	-	-	-	-	-	-	-	-	-	-	-
5941 ENG OPW1 469	ROAD CROSS SECTIONS - EASTRIDGE STREET SHEET 6 OF 8	B	-	-	-	-	-	-	-	-	-	-	-
5941 ENG OPW1 470	ROAD CROSS SECTIONS - EASTRIDGE STREET SHEET 7 OF 8	B	-	-	-	-	-	-	-	-	-	-	-
5941 ENG OPW1 471	ROAD CROSS SECTIONS - EASTRIDGE STREET SHEET 8 OF 8	B	-	-	-	-	-	-	-	-	-	-	-
5941 ENG OPW1 472	ROAD CROSS SECTIONS - FAIRWAY STREET SHEET 1 OF 6	C	-	D	-	-	-	-	-	-	D	-	-
5941 ENG OPW1 473	ROAD CROSS SECTIONS - FAIRWAY STREET SHEET 2 OF 6	C	-	D	-	-	-	-	-	-	D	-	-
5941 ENG OPW1 474	ROAD CROSS SECTIONS - FAIRWAY STREET SHEET 3 OF 6	C	-	-	-	-	-	-	-	-	-	-	-
5941 ENG OPW1 475	ROAD CROSS SECTIONS - FAIRWAY STREET SHEET 4 OF 6	C	-	-	-	-	-	-	-	-	-	-	-
5941 ENG OPW1 476	ROAD CROSS SECTIONS - FAIRWAY STREET SHEET 5 OF 6	C	-	-	-	-	-	-	-	-	-	-	-
5941 ENG OPW1 477	ROAD CROSS SECTIONS - FAIRWAY STREET SHEET 6 OF 6	C	-	-	-	-	-	-	-	-	-	-	-
5941 ENG OPW1 478	ROAD CROSS SECTIONS - EMERI STREET EXTENSION SHEET 1 OF 2	B	-	-	-	-	-	-	-	-	-	-	-
5941 ENG OPW1 479	ROAD CROSS SECTIONS - EMERI STREET EXTENSION SHEET 2 OF 2	B	-	-	-	-	-	-	-	-	-	-	-
5941 ENG OPW1 480	KERB ISLAND SETOUT DETAILS SHEET 1 OF 2	C	D	-	-	-	-	-	-	-	-	-	-
5941 ENG OPW1 481	KERB ISLAND SETOUT DETAILS SHEET 2 OF 2	C	-	-	-	-	-	-	-	-	-	-	-
5941 ENG OPW1 490	ROAD INTERSECTION DETAILS SHEET 1 OF 8	C	D	-	-	-	-	-	-	-	-	-	-
5941 ENG OPW1 491	ROAD INTERSECTION DETAILS SHEET 2 OF 8	C	-	-	-	-	-	-	-	-	-	-	-
5941 ENG OPW1 492	ROAD INTERSECTION DETAILS SHEET 3 OF 8	C	-	-	-	-	-	-	-	-	-	-	-
5941 ENG OPW1 493	ROAD INTERSECTION DETAILS SHEET 4 OF 8	C	-	-	-	-	-	-	-	-	-	-	-
5941 ENG OPW1 494	ROAD INTERSECTION DETAILS SHEET 5 OF 8	B	-	-	-	-	-	-	-	-	-	-	-
5941 ENG OPW1 495	ROAD INTERSECTION DETAILS SHEET 6 OF 8	B	-	-	-	-	-	-	-	-	-	-	-
5941 ENG OPW1 496	ROAD INTERSECTION DETAILS SHEET 7 OF 8	C	-	D	-	-	-	-	-	-	D	-	-
5941 ENG OPW1 497	ROAD INTERSECTION DETAILS SHEET 8 OF 8	C	-	-	-	-	-	-	-	-	-	-	-
5941 ENG OPW1 500	STORMWATER DRAINAGE CATCHMENT PLAN	C	D	E	-	-	-	-	-	-	E	-	-
5941 ENG OPW1 510	STORMWATER DRAINAGE LONGITUDINAL SECTIONS SHEET 1 OF 18	E	-	-	-	-	-	-	-	-	-	-	-
5941 ENG OPW1 511	STORMWATER DRAINAGE LONGITUDINAL SECTIONS SHEET 2 OF 18	E	-	-	-	-	-	-	-	-	-	-	-
5941 ENG OPW1 512	STORMWATER DRAINAGE LONGITUDINAL SECTIONS SHEET 3 OF 18	E	-	-	-	-	-	-	-	-	-	-	-
5941 ENG OPW1 513	STORMWATER DRAINAGE LONGITUDINAL SECTIONS SHEET 4 OF 18	D	-	E	-	-	-	-	-	-	E	-	-
5941 ENG OPW1 514	STORMWATER DRAINAGE LONGITUDINAL SECTIONS SHEET 5 OF 18	E	-	F	-	-	-	-	-	-	F	-	-
5941 ENG OPW1 515	STORMWATER DRAINAGE LONGITUDINAL SECTIONS SHEET 6 OF 18	E	-	-	-	-	-	-	-	-	-	-	-
5941 ENG OPW1 516	STORMWATER DRAINAGE LONGITUDINAL SECTIONS SHEET 7 OF 18	E	-	-	-	-	-	-	-	-	-	-	-
5941 ENG OPW1 517	STORMWATER DRAINAGE LONGITUDINAL SECTIONS SHEET 8 OF 18	E	-	-	-	-	-	-	-	-	-	-	-
5941 ENG OPW1 518	STORMWATER DRAINAGE LONGITUDINAL SECTIONS SHEET 9 OF 18	D	-	-	-	-	-	-	-	-	-	-	-
5941 ENG OPW1 519	STORMWATER DRAINAGE LONGITUDINAL SECTIONS SHEET 10 OF 18	D	-	-	-	-	-	-	-	-	-	-	-

DOCUMENT TRANSMITTAL SCHEDULE

To: City of Gold Coast Council

Address : PO Box 5042
GCMC 9726

Attention: Development Assessment

g a s s m a n

development perspectives



est 1985

planning | environment | landscape | engineering | survey

T: 07 3807 3333 | F: 07 3287 5461 | www.gassman.com.au
76 Business Street, Yatala QLD | PO Box 392, Beenleigh 4207

PROJECT:

OPERATIONAL WORKS APPLICATION FOR CIVIL WORKS
STAGE 1 VANTAGE YATALA (INDUSTRIAL DEVELOPMENT)

Job No: 5941

The documents listed below are issued for your use as indicated in the "Issued for" section.
All revisions supersede any revision of the same document.

DATE OF ISSUE	Day	28	12	27	30	05	21	24	26	24	07	31	10
	Month	10	03	04	04	05	05	05	05	06	07	08	09
	Year	20	21	21	21	21	21	21	21	21	21	21	21

Distribution:

Attention	Issued To												
City of Gold Coast Council	Development Assesment		1xPDF	1xPDF	1xPDF	1xPDF	1xPDF	1xPDF	1xPDF				1xPDF
FRASERS PROPERTY (AUSTRALIA) PTY. LTD	Commercial and Industrial	1xPDF											
SEE Civil	Leanne Shea - Project Manager									1xPDF	1xPDF	1xPDF	

Method:

- ☐ Our Mess.
- ☐ Your Mess.
- ☐ Hand
- ☐ Courier
- ☐ Mail
- ☒ FTP Site
- ☐ Email
- ☐ Aconex

C	A	A	A	A	A	A	A	C	C	C	A
C - Construction					T -Tender						
I - Information					O - Other						

The information in any Gassman Development Perspectives generated messages together with any attachments is intended only for the person or entity to which it is addressed and may contain confidential and/or privileged material. Any form of review, disclosure, modification, distribution and/or publication of this message is prohibited. If you have received this message in error, you are asked to inform the sender as quickly as possible and delete this message and any copies of this message from your computer and/or your computer system network.In relation to computer viruses, any loss or damage incurred by using this material is not the responsibility of the sender. The sending company's entire liability will be limited to resupplying the material. No warranty is made that this material is free from computer virus or other defect. Please consider the environment before printing any electronic media received from Gassman Development Persnectives.

C	A	A	A	A	A	A	A	C	C	C	A
C - Construction					T -Tender						
I - Information					O - Other						

EP	EP	EP	EP	EP	EP	EP	EP	EP	EP	EP	EP	EP
P Print				CP -CAD&PDF								
EP - PDF												

Drg/Doc No.	Title												
5941 ENG OPW1 520	STORMWATER DRAINAGE LONGITUDINAL SECTIONS SHEET 11 OF 18	D	-	-	-	-	-	-	-	-	-	-	-
5941 ENG OPW1 521	STORMWATER DRAINAGE LONGITUDINAL SECTIONS SHEET 12 OF 18	E	-	F	-	-	-	-	-	-	F	-	-
5941 ENG OPW1 522	STORMWATER DRAINAGE LONGITUDINAL SECTIONS SHEET 13 OF 18	E	-	-	-	-	-	-	-	-	F	-	-
5941 ENG OPW1 523	STORMWATER DRAINAGE LONGITUDINAL SECTIONS SHEET 14 OF 18	E	-	F	-	-	-	-	-	-	F	-	-
5941 ENG OPW1 524	STORMWATER DRAINAGE LONGITUDINAL SECTIONS SHEET 15 OF 18	D	-	-	-	-	-	-	-	-	-	-	-
5941 ENG OPW1 525	STORMWATER DRAINAGE LONGITUDINAL SECTIONS SHEET 16 OF 18	C	-	-	-	-	-	-	-	-	-	-	-
5941 ENG OPW1 526	STORMWATER DRAINAGE LONGITUDINAL SECTIONS SHEET 17 OF 18	E	-	-	-	-	-	-	-	-	-	-	-
5941 ENG OPW1 527	STORMWATER DRAINAGE LONGITUDINAL SECTIONS SHEET 18 OF 18	E	-	-	-	-	-	-	-	-	-	-	-
5941 ENG OPW1 550	39% AEP STORMWATER DRAINAGE CALCULATIONS TABLES SHEET 1 OF 2	B	-	C	-	-	-	-	-	-	C	-	-
5941 ENG OPW1 551	39% AEP STORMWATER DRAINAGE CALCULATIONS TABLES SHEET 2 OF 2	B	-	C	-	-	-	-	-	-	C	-	-
5941 ENG OPW1 552	1% AEP STORMWATER DRAINAGE CALCULATIONS TABLES SHEET 1 OF 2	B	-	C	-	-	-	-	-	-	C	-	-
5941 ENG OPW1 553	1% AEP STORMWATER DRAINAGE CALCULATIONS TABLES SHEET 2 OF 2	B	-	C	-	-	-	-	-	-	C	-	-
5941 ENG OPW1 570	OPERATIONAL PHASE BIORETENTION BASIN SHEET 1 OF 2	C	D	-	-	-	-	-	-	-	-	-	-
5941 ENG OPW1 571	OPERATIONAL PHASE BIORETENTION BASIN SHEET 2 OF 2	B	-	-	-	-	-	-	-	-	-	-	-
5941 ENG OPW1 572	OPERATIONAL PHASE BIORETENTION BASIN SETOUT DETAILS	C	-	-	-	-	-	-	-	-	-	-	-
5941 ENG OPW1 600	SEWER RETICULATION LAYOUT PLAN SHEET 1 OF 4	C	D	-	-	-	-	-	-	-	-	-	-
5941 ENG OPW1 601	SEWER RETICULATION LAYOUT PLAN SHEET 2 OF 4	C	-	D	-	-	-	-	-	-	D	-	-
5941 ENG OPW1 602	SEWER RETICULATION LAYOUT PLAN SHEET 3 OF 4	C	-	D	-	-	-	-	-	-	D	-	-
5941 ENG OPW1 603	SEWER RETICULATION LAYOUT PLAN SHEET 4 OF 4	C	-	-	-	-	-	-	-	-	-	-	-
5941-ENG-OPW1-604	250 DIA SEWER RISING MAIN LAYOUT PLAN SHEET 1 OF 4 (DELETED)	-	A	-	-	-	-	-	-	-	-	-	-
5941-ENG-OPW1-605	250 DIA SEWER RETICULATION LAYOUT PLAN SHEET 2 OF 4 (DELETED)	-	A	-	-	-	-	-	-	-	-	-	-
5941 ENG OPW1 606	100 DIA SEWER RETICULATION LAYOUT PLAN SHEET 3 OF 4	-	A	-	B	C	D	-	E	E	-	-	-
5941-ENG-OPW1-607	100 DIA SEWER RETICULATION LAYOUT PLAN SHEET 4 OF 4 (DELETED)	-	A	-	B	C		-	-	-	-	-	-
5941 ENG OPW1 610	SEWER RETICULATION LONGITUDINAL SECTIONS SHEET 1 OF 11	E	F	-	-	-	-	-	-	-	-	-	-
5941 ENG OPW1 611	SEWER RETICULATION LONGITUDINAL SECTIONS SHEET 2 OF 11	D	-	-	-	-	-	-	-	-	-	-	-
5941 ENG OPW1 612	SEWER RETICULATION LONGITUDINAL SECTIONS SHEET 3 OF 11	D	-	-	-	-	-	-	-	-	-	-	-
5941 ENG OPW1 613	SEWER RETICULATION LONGITUDINAL SECTIONS SHEET 4 OF 11	D	-	-	-	-	-	-	-	-	-	-	-
5941 ENG OPW1 614	SEWER RETICULATION LONGITUDINAL SECTIONS SHEET 5 OF 11	E	-	-	-	-	-	-	-	-	-	-	-
5941 ENG OPW1 615	SEWER RETICULATION LONGITUDINAL SECTIONS SHEET 6 OF 11	D	-	-	-	-	-	-	-	-	-	-	-
5941 ENG OPW1 616	SEWER RETICULATION LONGITUDINAL SECTIONS SHEET 7 OF 11	E	-	-	-	-	-	-	-	-	-	-	-
5941 ENG OPW1 617	SEWER RETICULATION LONGITUDINAL SECTIONS SHEET 8 OF 11	E	F	-	-	-	-	-	-	-	-	-	-
5941 ENG OPW1 618	SEWER RETICULATION LONGITUDINAL SECTIONS SHEET 9 OF 11	E	-	-	-	-	-	-	-	-	-	-	-
5941 ENG OPW1 619	SEWER RETICULATION LONGITUDINAL SECTIONS SHEET 10 OF 11	E	-	-	-	-	-	-	-	-	-	-	-
5941 ENG OPW1 620	SEWER RETICULATION LONGITUDINAL SECTIONS SHEET 11 OF 11	D	E	-	-	-	-	-	-	-	-	-	-
5941 ENG OPW1 621	100 DIA SEWER RISING MAIN LONGITUDINAL SECTION SHEET 1 OF 2	-	A	-	B	C	D	-	E	E	-	-	-
5941 ENG OPW1 622	90 DIA SEWER RISING MAIN LONGITUDINAL SECTION SHEET 2 OF 3	-	A	-	B	-	-	-	-	-	-	-	-
5941-ENG-OPW1-623	250 DIA SEWER RISING MAIN LONGITUDINAL SECTION SHEET 3 OF 3 (DELETED)	-	A	-	-	-	-	-	-	-	-	-	-
5941 ENG OPW1 624	100 DIA SEWER RISING MAIN CONNECTION DETAILS	-	A	-	-	-	B	-	C	C	-	-	-
5941 ENG OPW1 630	SEWER RISING MAIN TYPICAL DETAILS SHEET 1 OF 2	-	A	-	-	-	-	-	-	-	-	-	-
5941 ENG OPW1 631	SEWER RISING MAIN TYPICAL DETAILS SHEET 2 OF 2	-	A	-	-	-	-	-	-	-	-	-	-
5941 ENG OPW1 640	GENERAL ARRANGEMENT LAYOUT PLAN SHEET 1 OF 2	-	-	-	-	-	-	-	-	-	-	-	A
5941 ENG OPW1 641	GENERAL ARRANGEMENT LAYOUT PLAN SHEET 2 OF 2	-	-	-	-	-	-	-	-	-	-	-	A
5941 ENG OPW1 642	DETAILED GENERAL ARRANGEMENT LAYOUT PLAN SHEET 1 OF 2	-	-	-	-	-	-	-	-	-	-	-	A
5941 ENG OPW1 643	DETAILED GENERAL ARRANGEMENT LAYOUT PLAN SHEET 2 OF 2	-	-	-	-	-	-	-	-	-	-	-	A
5941 ENG OPW1 644	DETAILED BUOYANCY CALCULATIONS	-	-	-	-	-	-	-	-	-	-	-	A
5941 ENG OPW1 650	SEWER PUMP STATION SYSTEM LONGITUDINAL SECTION SHEET 1 OF 3	-	-	-	-	-	-	-	-	-	-	-	A

DOCUMENT TRANSMITTAL SCHEDULE

To: City of Gold Coast Council

Address : PO Box 5042
GCMC 9726

Attention: Development Assessment



PROJECT: OPERATIONAL WORKS APPLICATION FOR CIVIL WORKS
STAGE 1 VANTAGE YATALA (INDUSTRIAL DEVELOPMENT) Job No: 5941

The documents listed below are issued for your use as indicated in the "Issued for" section.
All revisions supersede any revision of the same document.

DATE OF ISSUE	Day	28	12	27	30	05	21	24	26	24	07	31	10
	Month	10	03	04	04	05	05	05	05	06	07	08	09
	Year	20	21	21	21	21	21	21	21	21	21	21	21

Distribution:													
Attention	Issued To												
City of Gold Coast Council	Development Assesment		1xPDF	1xPDF	1xPDF	1xPDF	1xPDF	1xPDF	1xPDF				1xPDF
FRASERS PROPERTY (AUSTRALIA) PTY. LTD	Commercial and Industrial	1xPDF											
SEE Civil	Leanne Shea - Project Manager									1xPDF	1xPDF	1xPDF	

Method:

☐ Our Mess.
☐ Your Mess.
☐ Hand

☐ Courier
☐ Mail
☒ FTP Site

☐ Email
☐ Aconex

C	A	A	A	A	A	A	A	C	C	C	A
C - Construction					T -Tender						
I - Information					O - Other						

The information in any Gassman Development Perspectives generated messages together with any attachments is intended only for the person or entity to which it is addressed and may contain confidential and/or privileged material. Any form of review, disclosure, modification, distribution and/or publication of this message is prohibited. If you have received this message in error, you are asked to inform the sender as quickly as possible and delete this message and any copies of this message from your computer and/or your computer system network. In relation to computer viruses, any loss or damage incurred by using this material is not the responsibility of the sender. The sending company's entire liability will be limited to resupplying the material. No warranty is made that this material is free from computer virus or other defect. Please consider the environment before printing any electronic media received from Gassman Development Perspectives.

EP	EP	EP	EP	EP	EP	EP	EP	EP	EP	EP	EP
P Print				CP -CAD&PDF							
EP - PDF											

Drg/Doc No.	Title												
5942 ENG OPW1 651	SEWER PUMP STATION SYSTEM LONGITUDINAL SECTION SHEET 2 OF 3	-	-	-	-	-	-	-	-	-	-	-	A
5943 ENG OPW1 652	SEWER PUMP STATION SYSTEM LONGITUDINAL SECTION SHEET 3 OF 3	-	-	-	-	-	-	-	-	-	-	-	A
5941 ENG OPW1 700	WATER RETICULATION LAYOUT PLAN SHEET 1 OF 4	C	D	-	E	-	-	-	-	-	-	F	G
5941 ENG OPW1 701	WATER RETICULATION LAYOUT PLAN SHEET 2 OF 4	C	-	D	-	-	-	-	-	-	D	-	-
5941 ENG OPW1 702	WATER RETICULATION LAYOUT PLAN SHEET 3 OF 4	C	-	-	-	-	-	-	-	-	-	-	-
5941 ENG OPW1 703	WATER RETICULATION LAYOUT PLAN SHEET 4 OF 4	C	-	-	-	-	-	-	-	-	-	-	-
5941 ENG OPW1 704	WATER RETICULATION TYPICAL DETAILS	B	-	-	-	-	-	-	-	-	-	-	-
5941 ENG OPW1 800	LINEMARKING AND SIGNAGE PLAN SHEET 1 OF 5	C	D	-	-	-	-	E	-	-	E	-	-
5941 ENG OPW1 801	LINEMARKING AND SIGNAGE PLAN SHEET 2 OF 5	B	-	-	-	-	-	C	-	-	C	-	-
5941 ENG OPW1 802	LINEMARKING AND SIGNAGE PLAN SHEET 3 OF 5	C	-	D	-	-	-	E	-	-	E	-	-
5941 ENG OPW1 803	LINEMARKING AND SIGNAGE PLAN SHEET 4 OF 5	C	-	-	-	-	-	D	-	-	D	-	-
5941 ENG OPW1 804	LINEMARKING AND SIGNAGE PLAN SHEET 5 OF 5	C	-	-	-	-	-	D	-	-	D	-	-

Please confirm that you have received all documents listed on the Document Register & Transmittal.

I hereby acknowledge receipt of the documents listed above.

Name & Company: Signed: Dated: / /

Project Manager: mitchell@gassman.com.au Sent by:


CIVIL OPERATIONAL WORKS VANTAGE YATALA - STAGE 1

DRAWING INDEX		
DRAWING No.	REV No.	DRAWING TITLE
594I ENG OPWI 001	J	DRAWING INDEX AND LOCALITY PLAN
594I ENG OPWI 002	B	GENERAL NOTES SHEET 1 OF 3
594I ENG OPWI 003	B	GENERAL NOTES SHEET 2 OF 3
594I ENG OPWI 004	B	GENERAL NOTES SHEET 3 OF 3
594I ENG OPWI 005	C	LEGEND
594I ENG OPWI 006	D	KEY PLAN LAYOUT
594I ENG OPWI 010	B	EXISTING SURFACE AND FEATURE PLAN
594I ENG OPWI 020	B	EMERI STREET DEMOLITION AND PROTECTION LAYOUT PLAN
594I ENG OPWI 050	D	SEDIMENT AND EROSION CONTROL PLAN SHEET 1 OF 6
594I ENG OPWI 051	B	SEDIMENT AND EROSION CONTROL PLAN SHEET 2 OF 6
594I ENG OPWI 052	C	SEDIMENT AND EROSION CONTROL PLAN SHEET 3 OF 6
594I ENG OPWI 053	D	SEDIMENT AND EROSION CONTROL PLAN SHEET 4 OF 6
594I ENG OPWI 054	C	SEDIMENT AND EROSION CONTROL PLAN SHEET 5 OF 6
594I ENG OPWI 055	C	SEDIMENT AND EROSION CONTROL PLAN SHEET 6 OF 6
594I ENG OPWI 056	D	CONSTRUCTION PHASE SEDIMENT BASIN 1 LAYOUT
594I ENG OPWI 057	B	CONSTRUCTION PHASE SEDIMENT BASIN 1 SECTIONS
594I ENG OPWI 058	B	CONSTRUCTION PHASE SEDIMENT BASIN 2 LAYOUT
594I ENG OPWI 059	B	CONSTRUCTION PHASE SEDIMENT BASIN 2 SECTIONS
594I ENG OPWI 060	B	SEDIMENT AND EROSION TYPICAL DETAILS
594I ENG OPWI 300	D	OVERALL SERVICES LAYOUT PLAN SHEET 1 OF 4
594I ENG OPWI 301	D	OVERALL SERVICES LAYOUT PLAN SHEET 2 OF 4
594I ENG OPWI 302	C	OVERALL SERVICES LAYOUT PLAN SHEET 3 OF 4
594I ENG OPWI 303	C	OVERALL SERVICES LAYOUT PLAN SHEET 4 OF 4
594I ENG OPWI 400	D	ROADWORKS AND DRAINAGE LAYOUT PLAN SHEET 1 OF 4
594I ENG OPWI 401	D	ROADWORKS AND DRAINAGE LAYOUT PLAN SHEET 2 OF 4
594I ENG OPWI 402	D	ROADWORKS AND DRAINAGE LAYOUT PLAN SHEET 3 OF 4
594I ENG OPWI 403	C	ROADWORKS AND DRAINAGE LAYOUT PLAN SHEET 4 OF 4
594I ENG OPWI 410	C	TYPICAL SECTIONS AND DETAILS SHEET 1 OF 3
594I ENG OPWI 411	C	TYPICAL SECTIONS AND DETAILS SHEET 2 OF 3
594I ENG OPWI 412	B	TYPICAL SECTIONS AND DETAILS SHEET 3 OF 3
594I ENG OPWI 420	E	CONTROL LINE LAYOUT PLAN
594I ENG OPWI 421	D	ROAD CONTROL LINE SETOUT TABLES SHEET 1 OF 2
594I ENG OPWI 422	D	ROAD CONTROL LINE SETOUT TABLES SHEET 2 OF 2
594I ENG OPWI 430	D	ROAD LONGITUDINAL SECTION – HOMESTEAD DRIVE SHEET 1 OF 3
594I ENG OPWI 431	C	ROAD LONGITUDINAL SECTION – HOMESTEAD DRIVE SHEET 2 OF 3
594I ENG OPWI 432	C	ROAD LONGITUDINAL SECTION – HOMESTEAD DRIVE SHEET 3 OF 3
594I ENG OPWI 433	C	ROAD LONGITUDINAL SECTION – EASTRIDGE STREET SHEET 1 OF 2
594I ENG OPWI 434	C	ROAD LONGITUDINAL SECTION – EASTRIDGE STREET SHEET 2 OF 2
594I ENG OPWI 435	D	ROAD LONGITUDINAL SECTION – FAIRWAY STREET SHEET 1 OF 2
594I ENG OPWI 436	C	ROAD LONGITUDINAL SECTION – FAIRWAY STREET SHEET 2 OF 2
594I ENG OPWI 437	B	ROAD LONGITUDINAL SECTION – EMERI STREET EXTENSION
594I ENG OPWI 450	D	ROAD CROSS SECTIONS – HOMESTEAD DRIVE SHEET 1 OF 14
594I ENG OPWI 451	C	ROAD CROSS SECTIONS – HOMESTEAD DRIVE SHEET 2 OF 14
594I ENG OPWI 452	C	ROAD CROSS SECTIONS – HOMESTEAD DRIVE SHEET 3 OF 14
594I ENG OPWI 453	C	ROAD CROSS SECTIONS – HOMESTEAD DRIVE SHEET 4 OF 14
594I ENG OPWI 454	C	ROAD CROSS SECTIONS – HOMESTEAD DRIVE SHEET 5 OF 14
594I ENG OPWI 455	C	ROAD CROSS SECTIONS – HOMESTEAD DRIVE SHEET 6 OF 14
594I ENG OPWI 456	C	ROAD CROSS SECTIONS – HOMESTEAD DRIVE SHEET 7 OF 14
594I ENG OPWI 457	C	ROAD CROSS SECTIONS – HOMESTEAD DRIVE SHEET 8 OF 14
594I ENG OPWI 458	C	ROAD CROSS SECTIONS – HOMESTEAD DRIVE SHEET 9 OF 14
594I ENG OPWI 459	C	ROAD CROSS SECTIONS – HOMESTEAD DRIVE SHEET 10 OF 14
594I ENG OPWI 460	C	ROAD CROSS SECTIONS – HOMESTEAD DRIVE SHEET 11 OF 14
594I ENG OPWI 461	C	ROAD CROSS SECTIONS – HOMESTEAD DRIVE SHEET 12 OF 14
594I ENG OPWI 462	C	ROAD CROSS SECTIONS – HOMESTEAD DRIVE SHEET 13 OF 14
594I ENG OPWI 463	C	ROAD CROSS SECTIONS – HOMESTEAD DRIVE SHEET 14 OF 14
594I ENG OPWI 464	B	ROAD CROSS SECTIONS – EASTRIDGE STREET SHEET 1 OF 8
594I ENG OPWI 465	B	ROAD CROSS SECTIONS – EASTRIDGE STREET SHEET 2 OF 8
594I ENG OPWI 466	B	ROAD CROSS SECTIONS – EASTRIDGE STREET SHEET 3 OF 8
594I ENG OPWI 467	B	ROAD CROSS SECTIONS – EASTRIDGE STREET SHEET 4 OF 8
594I ENG OPWI 468	B	ROAD CROSS SECTIONS – EASTRIDGE STREET SHEET 5 OF 8
594I ENG OPWI 469	B	ROAD CROSS SECTIONS – EASTRIDGE STREET SHEET 6 OF 8
594I ENG OPWI 470	B	ROAD CROSS SECTIONS – EASTRIDGE STREET SHEET 7 OF 8
594I ENG OPWI 471	B	ROAD CROSS SECTIONS – EASTRIDGE STREET SHEET 8 OF 8
594I ENG OPWI 472	D	ROAD CROSS SECTIONS – FAIRWAY STREET SHEET 1 OF 6
594I ENG OPWI 473	D	ROAD CROSS SECTIONS – FAIRWAY STREET SHEET 2 OF 6
594I ENG OPWI 474	C	ROAD CROSS SECTIONS – FAIRWAY STREET SHEET 3 OF 6
594I ENG OPWI 475	C	ROAD CROSS SECTIONS – FAIRWAY STREET SHEET 4 OF 6
594I ENG OPWI 476	C	ROAD CROSS SECTIONS – FAIRWAY STREET SHEET 5 OF 6
594I ENG OPWI 477	C	ROAD CROSS SECTIONS – FAIRWAY STREET SHEET 6 OF 6

DRAWING INDEX		
DRAWING No.	REV No.	DRAWING TITLE
594I ENG OPWI 478	B	ROAD CROSS SECTIONS – EMERI STREET EXTENSION SHEET 1 OF 2
594I ENG OPWI 479	C	ROAD CROSS SECTIONS – EMERI STREET EXTENSION SHEET 2 OF 2
594I ENG OPWI 480	D	KERB ISLAND SETOUT DETAILS SHEET 1 OF 2
594I ENG OPWI 481	C	KERB ISLAND SETOUT DETAILS SHEET 2 OF 2
594I ENG OPWI 490	D	ROAD INTERSECTION DETAILS SHEET 1 OF 8
594I ENG OPWI 491	C	ROAD INTERSECTION DETAILS SHEET 2 OF 8
594I ENG OPWI 492	C	ROAD INTERSECTION DETAILS SHEET 3 OF 8
594I ENG OPWI 493	C	ROAD INTERSECTION DETAILS SHEET 4 OF 8
594I ENG OPWI 494	B	ROAD INTERSECTION DETAILS SHEET 5 OF 8
594I ENG OPWI 495	B	ROAD INTERSECTION DETAILS SHEET 6 OF 8
594I ENG OPWI 496	D	ROAD INTERSECTION DETAILS SHEET 7 OF 8
594I ENG OPWI 497	C	ROAD INTERSECTION DETAILS SHEET 8 OF 8
594I ENG OPWI 500	E	STORMWATER DRAINAGE CATCHMENT PLAN
594I ENG OPWI 510	E	STORMWATER DRAINAGE LONGITUDINAL SECTIONS SHEET 1 OF 18
594I ENG OPWI 511	E	STORMWATER DRAINAGE LONGITUDINAL SECTIONS SHEET 2 OF 18
594I ENG OPWI 512	E	STORMWATER DRAINAGE LONGITUDINAL SECTIONS SHEET 3 OF 18
594I ENG OPWI 513	E	STORMWATER DRAINAGE LONGITUDINAL SECTIONS SHEET 4 OF 18
594I ENG OPWI 514	F	STORMWATER DRAINAGE LONGITUDINAL SECTIONS SHEET 5 OF 18
594I ENG OPWI 515	E	STORMWATER DRAINAGE LONGITUDINAL SECTIONS SHEET 6 OF 18
594I ENG OPWI 516	E	STORMWATER DRAINAGE LONGITUDINAL SECTIONS SHEET 7 OF 18
594I ENG OPWI 517	E	STORMWATER DRAINAGE LONGITUDINAL SECTIONS SHEET 8 OF 18
594I ENG OPWI 518	D	STORMWATER DRAINAGE LONGITUDINAL SECTIONS SHEET 9 OF 18
594I ENG OPWI 519	D	STORMWATER DRAINAGE LONGITUDINAL SECTIONS SHEET 10 OF 18
594I ENG OPWI 520	D	STORMWATER DRAINAGE LONGITUDINAL SECTIONS SHEET 11 OF 18
594I ENG OPWI 521	F	STORMWATER DRAINAGE LONGITUDINAL SECTIONS SHEET 12 OF 18
594I ENG OPWI 522	E	STORMWATER DRAINAGE LONGITUDINAL SECTIONS SHEET 13 OF 18
594I ENG OPWI 523	F	STORMWATER DRAINAGE LONGITUDINAL SECTIONS SHEET 14 OF 18
594I ENG OPWI 524	D	STORMWATER DRAINAGE LONGITUDINAL SECTIONS SHEET 15 OF 18
594I ENG OPWI 525	C	STORMWATER DRAINAGE LONGITUDINAL SECTIONS SHEET 16 OF 18
594I ENG OPWI 526	E	STORMWATER DRAINAGE LONGITUDINAL SECTIONS SHEET 17 OF 18
594I ENG OPWI 527	D	STORMWATER DRAINAGE LONGITUDINAL SECTIONS SHEET 18 OF 18
594I ENG OPWI 550	C	39% AEP STORMWATER DRAINAGE CALCULATIONS TABLES SHEET 1 OF 2
594I ENG OPWI 551	C	39% AEP STORMWATER DRAINAGE CALCULATIONS TABLES SHEET 2 OF 2
594I ENG OPWI 552	C	1% AEP STORMWATER DRAINAGE CALCULATIONS TABLES SHEET 1 OF 2
594I ENG OPWI 553	C	1% AEP STORMWATER DRAINAGE CALCULATIONS TABLES SHEET 2 OF 2
594I ENG OPWI 570	D	OPERATIONAL PHASE BIORETENTION BASIN SHEET 1 OF 2
594I ENG OPWI 571	B	OPERATIONAL PHASE BIORETENTION BASIN SHEET 2 OF 2
594I ENG OPWI 572	C	OPERATIONAL PHASE BIORETENTION BASIN SETOUT DETAILS
594I ENG OPWI 600	D	SEWER RETICULATION LAYOUT PLAN SHEET 1 OF 4
594I ENG OPWI 601	D	SEWER RETICULATION LAYOUT PLAN SHEET 2 OF 4
594I ENG OPWI 602	D	SEWER RETICULATION LAYOUT PLAN SHEET 3 OF 4
594I ENG OPWI 603	C	SEWER RETICULATION LAYOUT PLAN SHEET 4 OF 4
594I ENG OPWI 606	B	100% SEWER RISING MAIN LAYOUT PLAN SHEET 3 OF 4
594I ENG OPWI 610	F	SEWER RETICULATION LONGITUDINAL SECTIONS SHEET 1 OF 11
594I ENG OPWI 611	D	SEWER RETICULATION LONGITUDINAL SECTIONS SHEET 2 OF 11
594I ENG OPWI 612	D	SEWER RETICULATION LONGITUDINAL SECTIONS SHEET 3 OF 11
594I ENG OPWI 613	D	SEWER RETICULATION LONGITUDINAL SECTIONS SHEET 4 OF 11
594I ENG OPWI 614	E	SEWER RETICULATION LONGITUDINAL SECTIONS SHEET 5 OF 11
594I ENG OPWI 615	D	SEWER RETICULATION LONGITUDINAL SECTIONS SHEET 6 OF 11
594I ENG OPWI 616	E	SEWER RETICULATION LONGITUDINAL SECTIONS SHEET 7 OF 11
594I ENG OPWI 617	F	SEWER RETICULATION LONGITUDINAL SECTIONS SHEET 8 OF 11
594I ENG OPWI 618	E	SEWER RETICULATION LONGITUDINAL SECTIONS SHEET 9 OF 11
594I ENG OPWI 619	E	SEWER RETICULATION LONGITUDINAL SECTIONS SHEET 10 OF 11
594I ENG OPWI 620	E	SEWER RETICULATION LONGITUDINAL SECTIONS SHEET 11 OF 11
594I ENG OPWI 621	A	100% SEWER RISING MAIN LONGITUDINAL SECTION SHEET 1 OF 3
594I ENG OPWI 622	A	90% SEWER RISING MAIN LONGITUDINAL SECTION SHEET 2 OF 3
594I ENG OPWI 624	A	100% EXISTING SEWER RISING MAIN LONGITUDINAL SECTION
594I ENG OPWI 630	A	SEWER RISING MAIN TYPICAL DETAILS SHEET 1 OF 2
594I ENG OPWI 631	A	SEWER RISING MAIN TYPICAL DETAILS SHEET 2 OF 2
594I ENG OPWI 640	A	GENERAL ARRANGEMENT LAYOUT PLAN SHEET 1 OF 2
594I ENG OPWI 641	A	GENERAL ARRANGEMENT LAYOUT PLAN SHEET 2 OF 2
594I ENG OPWI 642	A	DETAILED GENERAL ARRANGEMENT LAYOUT SHEET 1 OF 2
594I ENG OPWI 643	A	DETAILED GENERAL ARRANGEMENT LAYOUT SHEET 2 OF 2
594I ENG OPWI 644	A	DETAILED BUOYANCY CALCULATIONS
594I ENG OPWI 650	A	SEWER PUMP STATION SYSTEM LONGITUDINAL SECTION SHEET 1 OF 3
594I ENG OPWI 651	A	SEWER PUMP STATION SYSTEM LONGITUDINAL SECTION SHEET 2 OF 3
594I ENG OPWI 652	A	SEWER PUMP STATION SYSTEM LONGITUDINAL SECTION SHEET 3 OF 3
594I ENG OPWI 700	G	WATER RETICULATION LAYOUT PLAN SHEET 1 OF 4
594I ENG OPWI 701	D	WATER RETICULATION LAYOUT PLAN SHEET 2 OF 4

DRAWING INDEX		
DRAWING No.	REV No.	DRAWING TITLE
594I ENG OPWI 702	C	WATER RETICULATION LAYOUT PLAN SHEET 3 OF 4
594I ENG OPWI 703	C	WATER RETICULATION LAYOUT PLAN SHEET 4 OF 4
594I ENG OPWI 704	B	WATER RETICULATION TYPICAL DETAILS
594I ENG OPWI 800	D	LINEMARKING AND SIGNAGE PLAN SHEET 1 OF 5
594I ENG OPWI 801	C	LINEMARKING AND SIGNAGE PLAN SHEET 2 OF 5
594I ENG OPWI 802	D	LINEMARKING AND SIGNAGE PLAN SHEET 3 OF 5
594I ENG OPWI 803	D	LINEMARKING AND SIGNAGE PLAN SHEET 4 OF 5
594I ENG OPWI 804	D	LINEMARKING AND SIGNAGE PLAN SHEET 5 OF 5
594I ENG OPWI 900	A	A–DOUBLE SWEEP PATH ANALYSIS MASTER PLAN
594I ENG OPWI 901	A	A–DOUBLE SWEEP PATH ANALYSIS SHEET 1 OF 7
594I ENG OPWI 902	A	A–DOUBLE SWEEP PATH ANALYSIS SHEET 2 OF 7
594I ENG OPWI 903	A	A–DOUBLE SWEEP PATH ANALYSIS SHEET 3 OF 7
594I ENG OPWI 904	A	A–DOUBLE SWEEP PATH ANALYSIS SHEET 4 OF 7
594I ENG OPWI 905	A	A–DOUBLE SWEEP PATH ANALYSIS SHEET 5 OF 7
594I ENG OPWI 906	A	A–DOUBLE SWEEP PATH ANALYSIS SHEET 6 OF 7
594I ENG OPWI 907	A	A–DOUBLE SWEEP PATH ANALYSIS SHEET 7 OF 7

STANDARD DRAWINGS			
DRAWING No.	REV.	ASSOCIATION	DRAWING TITLE
DS–010	F	IPWEA	ACCESS CHAMBER – STORMWATER ACCESS CHAMBER DETAILS – 1050 TO 2100 DIA
DS–015	C	IPWEA	ACCESS CHAMBER – MANHOLE FRAME – ROADWAY AND NON ROADWAY – 1050 TO 2100 DIA
DS–018	C	IPWEA	ACCESS CHAMBER – MANHOLE RISER DETAILS
DS–019	C	IPWEA	ACCESS CHAMBER – MANHOLE ROVER (ROADWAY)
DS–020	C	IPWEA	ACCESS CHAMBER – MANHOLE ROVER (NON ROADWAY)
DS–021	C	IPWEA	ACCESS CHAMBER – MANHOLE COVER CONCRETE INFILL (PEDESTRIAN TRAFFIC) 1050 TO 2100 DIA
DS–030	F	IPWEA	EXCAVATION, BEDDING & BACKFILL – RIGID & FLEXIBLE DRAINAGE PIPES
DS–031	D	IPWEA	EXCAVATION, BEDDING & BACKFILL PRECAST – BOX CULVERTS
DS–040	E	IPWEA	SEDIMENT CONTROL – SEDIMENT CONTROL DEVICES – SEDIMENT FENCE, ENTRY/EXIT SEDIMENT TRAP
DS–041	E	IPWEA	SEDIMENT CONTROL – SEDIMENT CONTROL DEVICES – KERB AND FIELD INLET, CHECK DAMS & STRAW BALES
DS–050	E	IPWEA	DRAINAGE PITS – FIELD INLET TYPE 1 AND TYPE 2
DS–061	B	IPWEA	DRAINAGE PITS – KERB INLET – PRECAST LINTEL DETAILS
DS–062	D	IPWEA	DRAINAGE PITS – KERB INLET – GRATE AND FRAME
DS–063	C	IPWEA	DRAINAGE PITS – KERB INLET – LIP IN LINE – GENERAL ARRANGEMENT
DS–065	I	IPWEA	PATHWAYS – CONCRETE PATHWAY CONSTRUCTION DETAILS
DS–073	A	IPWEA	BIORETENTION DRAINAGE PROFILE – TYPE 3 – CONVENTIONAL
DS–075	A	IPWEA	LARGE BIORETENTION SEDIMENT FOREBAY
DS–076	A	IPWEA	BIORETENTION WEIR
DS–078	A	IPWEA	BIORETENTION STANDARD NOTES
GS–041	D	IPWEA	FENCING – CHAIN WIRE SECURITY FENCING
RS–049	E	IPWEA	VEHICLE CROSSING – RESIDENTIAL DRIVEWAYS – PLAN 1 OF 2
RS–050	G	IPWEA	VEHICLE CROSSING – RESIDENTIAL DRIVEWAYS – PLAN 2 OF 2
RS–080	F	IPWEA	KERB AND CHANNEL – PROFILES AND DIMENSIONS – INCLUDING EDGE RESTRAINTS, MEDIAN & CHANNEL
RS–090	J	IPWEA	KERB RAMPS – RAMPED PEDESTRIAN
RS–091	F	IPWEA	KERB RAMPS – RAMPED AND CUT THROUGH TREATMENTS – FOR PEDESTRIAN CROSSINGS, SLIP LANES AND MEDIANS
RS–094	F	IPWEA	KERB RAMPS – LOCATIONS AND CONFIGURATIONS
RS–130	F	IPWEA	ROAD FURNITURE – STREET NAME SIGN AND LOCATION (FINGERBOARD)
RS–131	G	IPWEA	ROAD FURNITURE – TRAFFIC SIGN INSTALLATION DETAILS
RS–140	F	IPWEA	SUBSOIL DRAINS – DETAILS AND LOCATION
RS–142	F	IPWEA	SUBSOIL DRAINS – ACCESS POINTS
SD1033	K	DTMR	KERB AND CHANNEL
SD1304	N	DTMR	PIPE CULVERTS – WINGWALLS, HEADWALLS AND APRON FOR PIPE DIA 750 TO 2400
02–003	2	CoGC	TYPICAL CROSS SECTIONS – COLLECTOR STREETS – PLAN 2 OF 2
02–005	I	CoGC	PUBLIC UTILITY PLANT CORRIDOR ALLOCATIONS IN PUBLIC ROAD VERGES
02–601	I	CoGC	NEW ROADS – SERVICE CONDUIT CROSSINGS
02–602	I	CoGC	ROAD CROSSING – TRENCH RESTORATION – FLEXIBLE PAVEMENTS
03–008	I	CoGC	FIELD INLET AND INTER–ALLOTMENT DRAINAGE PIT
03–101	I	CoGC	STORMWATER ACCESS CHAMBER 1050 DIA TO 1500 DIA
03–102	I	CoGC	STORMWATER ACCESS CHAMBER 1050 DIA TO 1500 DIA ROOF SLABS
03–201	I	CoGC	EXCAVATION AND BEDDING OF CONCRETE STORMWATER PIPES
05–014	I	CoGC	CHAIN WIRE FENCING – 1.8m HIGH
SEQ–SPS–1602–1	C	SEQ	RIISING MAIN SCOUR/ DRAIN ARRANGEMENT
SEQ–SPS–1606–1	B	SEQ	AUTOMATIC GAS RELEASE VALVE

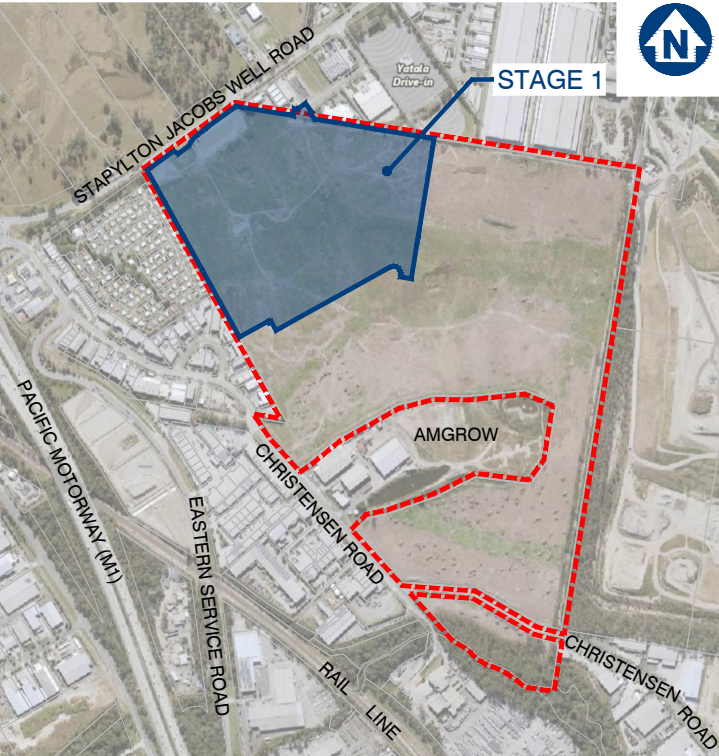

LOCALITY PLAN

SCALE 1: 8000 (A1)

CLIENT



**FRASERS
PROPERTY**


**FRASERS PROPERTY
(AUSTRALIA) PTY. LTD.**

SITE ADDRESS


**60 STAPYLTON JACOBS WELL ROAD
STAPYLTON QLD 4207**

DWG No. 594I ENG OPWI 001 – REV J

SEPTEMBER 2021

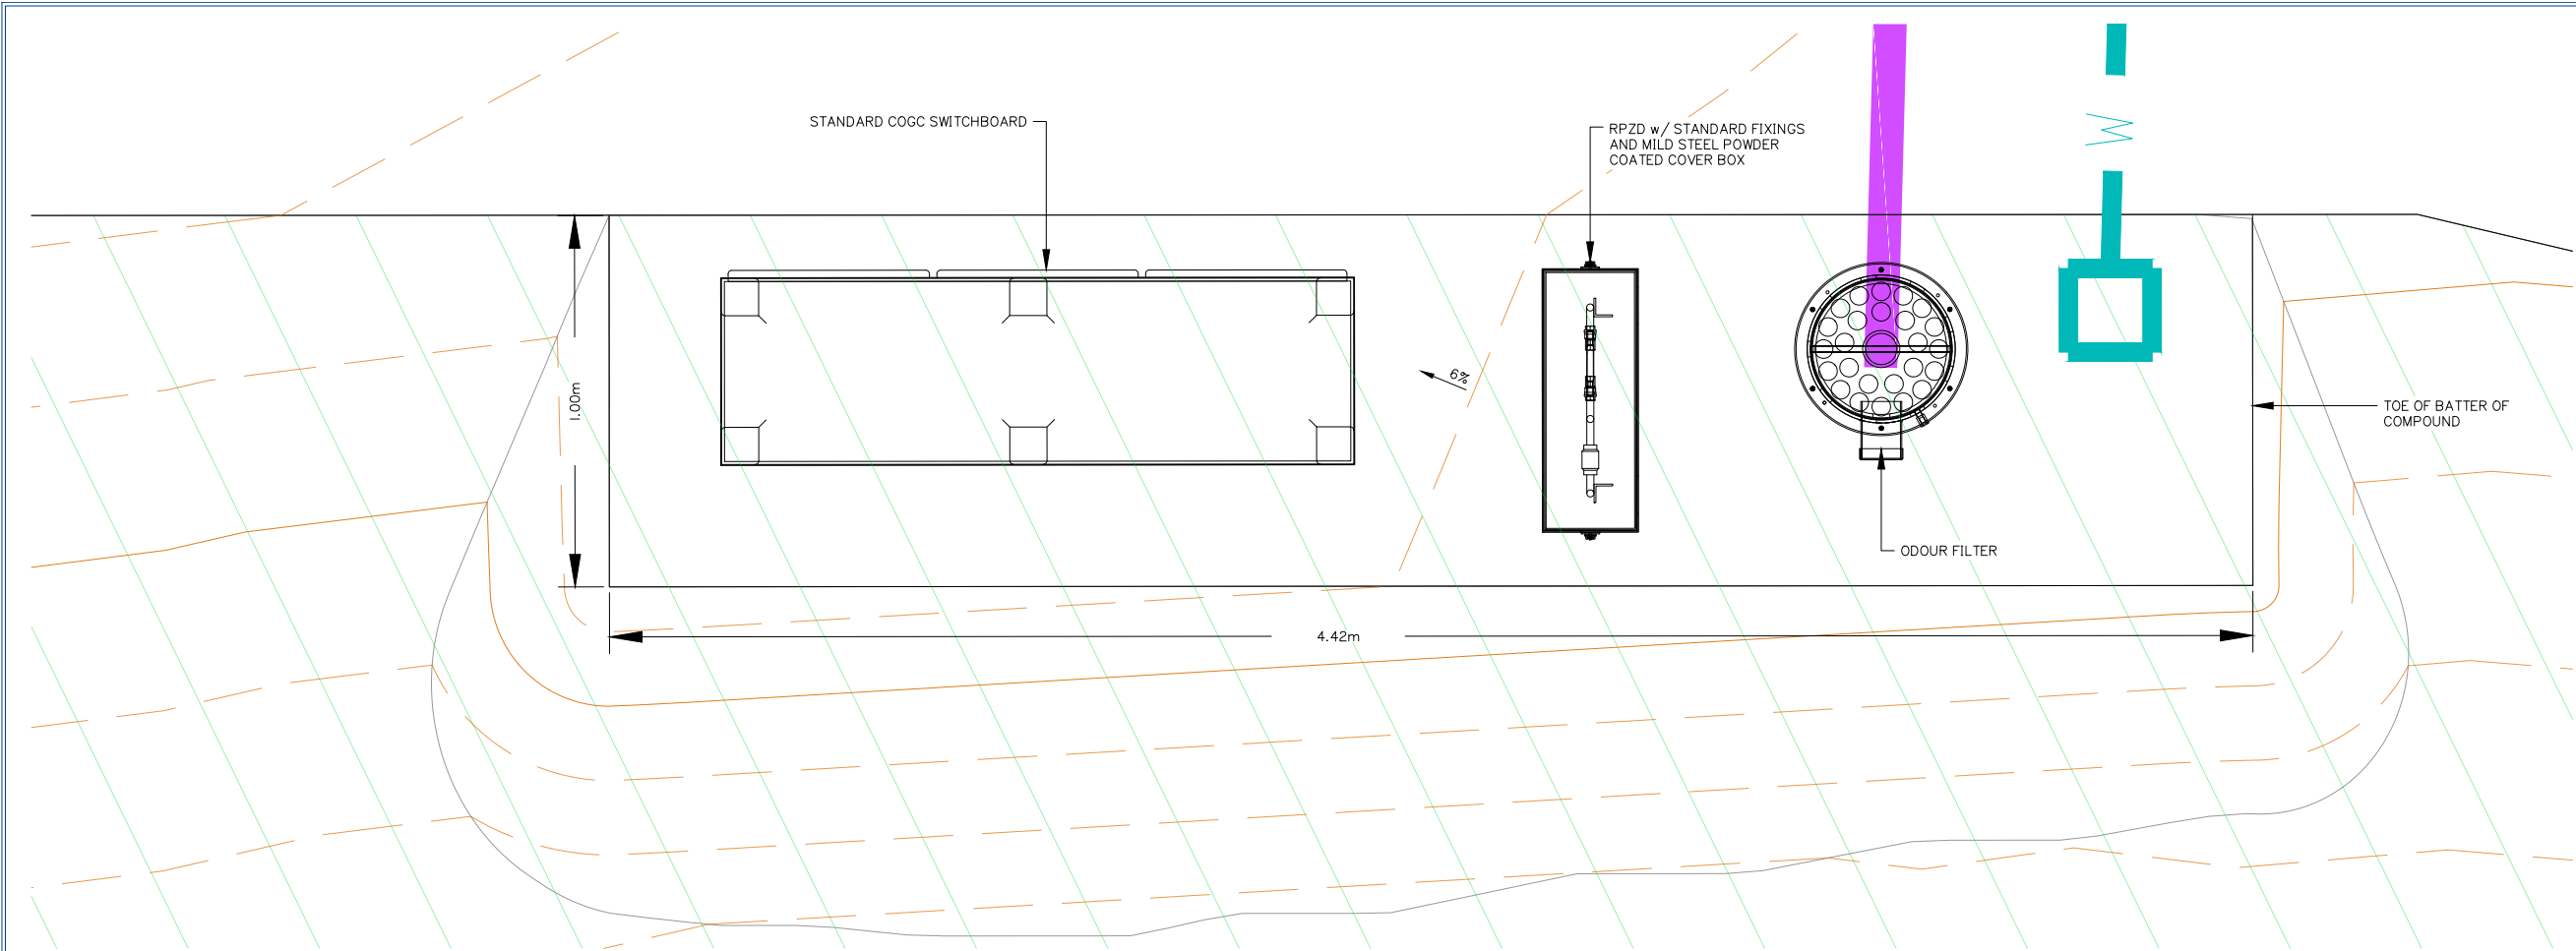

STANDARD CoCG SWITCHBOARD COMPOUND

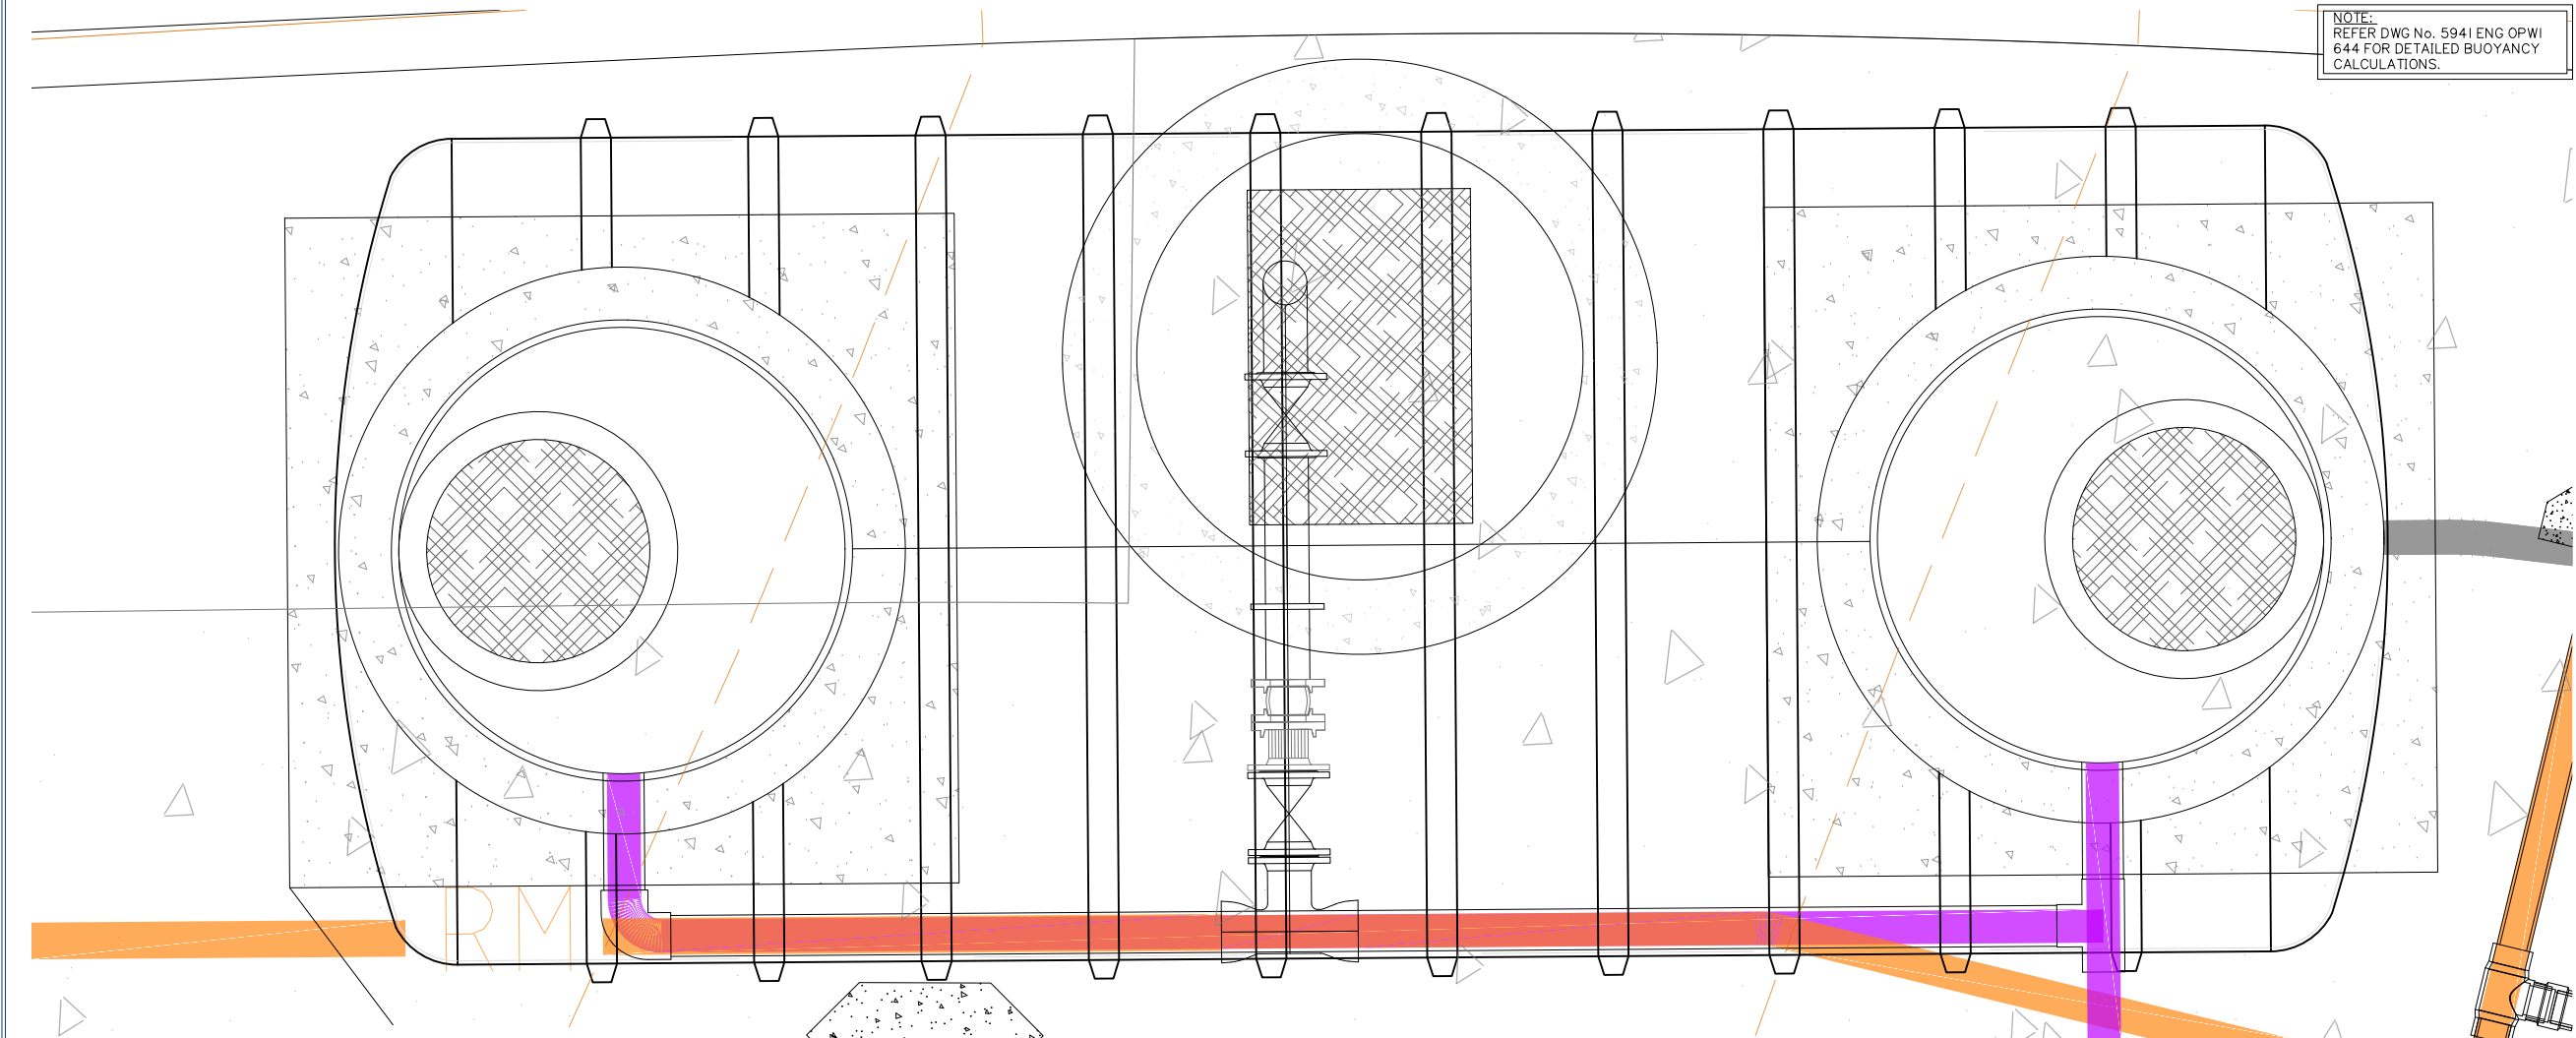

EMERGENCY STORAGE VESSEL

Issue	Date	Original Issue	Description	Lab	MG	CHK
A	03-09-2021	ORIGINAL ISSUE		LAB	MG	

SCALE IN METRES
0 0.2 0.4 0.6 0.8 10
1:10 (FULL SIZE A1)
1:20 (HALF SIZE A3)

Scale at A1:	1:10
Designed:	IG
Drafted:	LAB
Approved:	MG
RPEQ:	16939
Signed:	
Date:	09-09-2021



FRASERS PROPERTY
(AUSTRALIA) PTY. LTD.

VANTAGE YATALA STAGE 1

60 STAPYLTON JACOBS WELL
ROAD, STAPYLTON QLD 4207

THIS DRAWING IS INTENDED TO
BE PRINTED IN COLOUR

Lot:	501
Plan:	SP295994
Local Authority:	CITY OF GOLD COAST COUNCIL
Level Datum:	AHD
Meridian:	-
Contour Interval:	-
PSM:	-
RL:	-

ISSUED FOR APPROVAL
NOT FOR CONSTRUCTION

©2012 Gassman Development Perspectives
All rights reserved. No part of this document may be reproduced or transmitted in any form or by any means, electronic, mechanical, photocopying, recording, or otherwise, without the written permission of Gassman Development Perspectives.

ALL DRAWINGS ARE TO BE READ IN CONJUNCTION WITH GENERAL NOTES

SEWER PUMP STATION
SYSTEM LONGITUDINAL
SECTION SHEET 1 OF 3[illegible]

1:25 (FULL SIZE A1)
1:50 (HALF SIZE A3)

Scale at A1:	1:25
--------------	------

Designed:	IG
-----------	----

Drafted:	LAB
----------	-----

Approved:	MG
-----------	----

RPEQ:	16939
-------	-------

Signed:	<i>Milke</i>
---------	--------------

Date:	09-09
-------	-------

Drawing No:	Rev. No:
5941 ENG OPW1 650	A



03-09-2021		ORIGINAL ISSUE		LAB
Date		Description		DRN

SCALE IN METRES




0.5 1.0 1.5 2.0 2.5

1:25 (FULL SIZE A1)
1:50 (HALF SIZE A3)

Scale at A1: 1:25

Designed:	IG
Drafted:	LAB
Approved:	MG
PEQ:	16939
Signed:	
Date:	09-09-2021

Drawing No:	Rev. No:
41 ENG OPW1 651	A

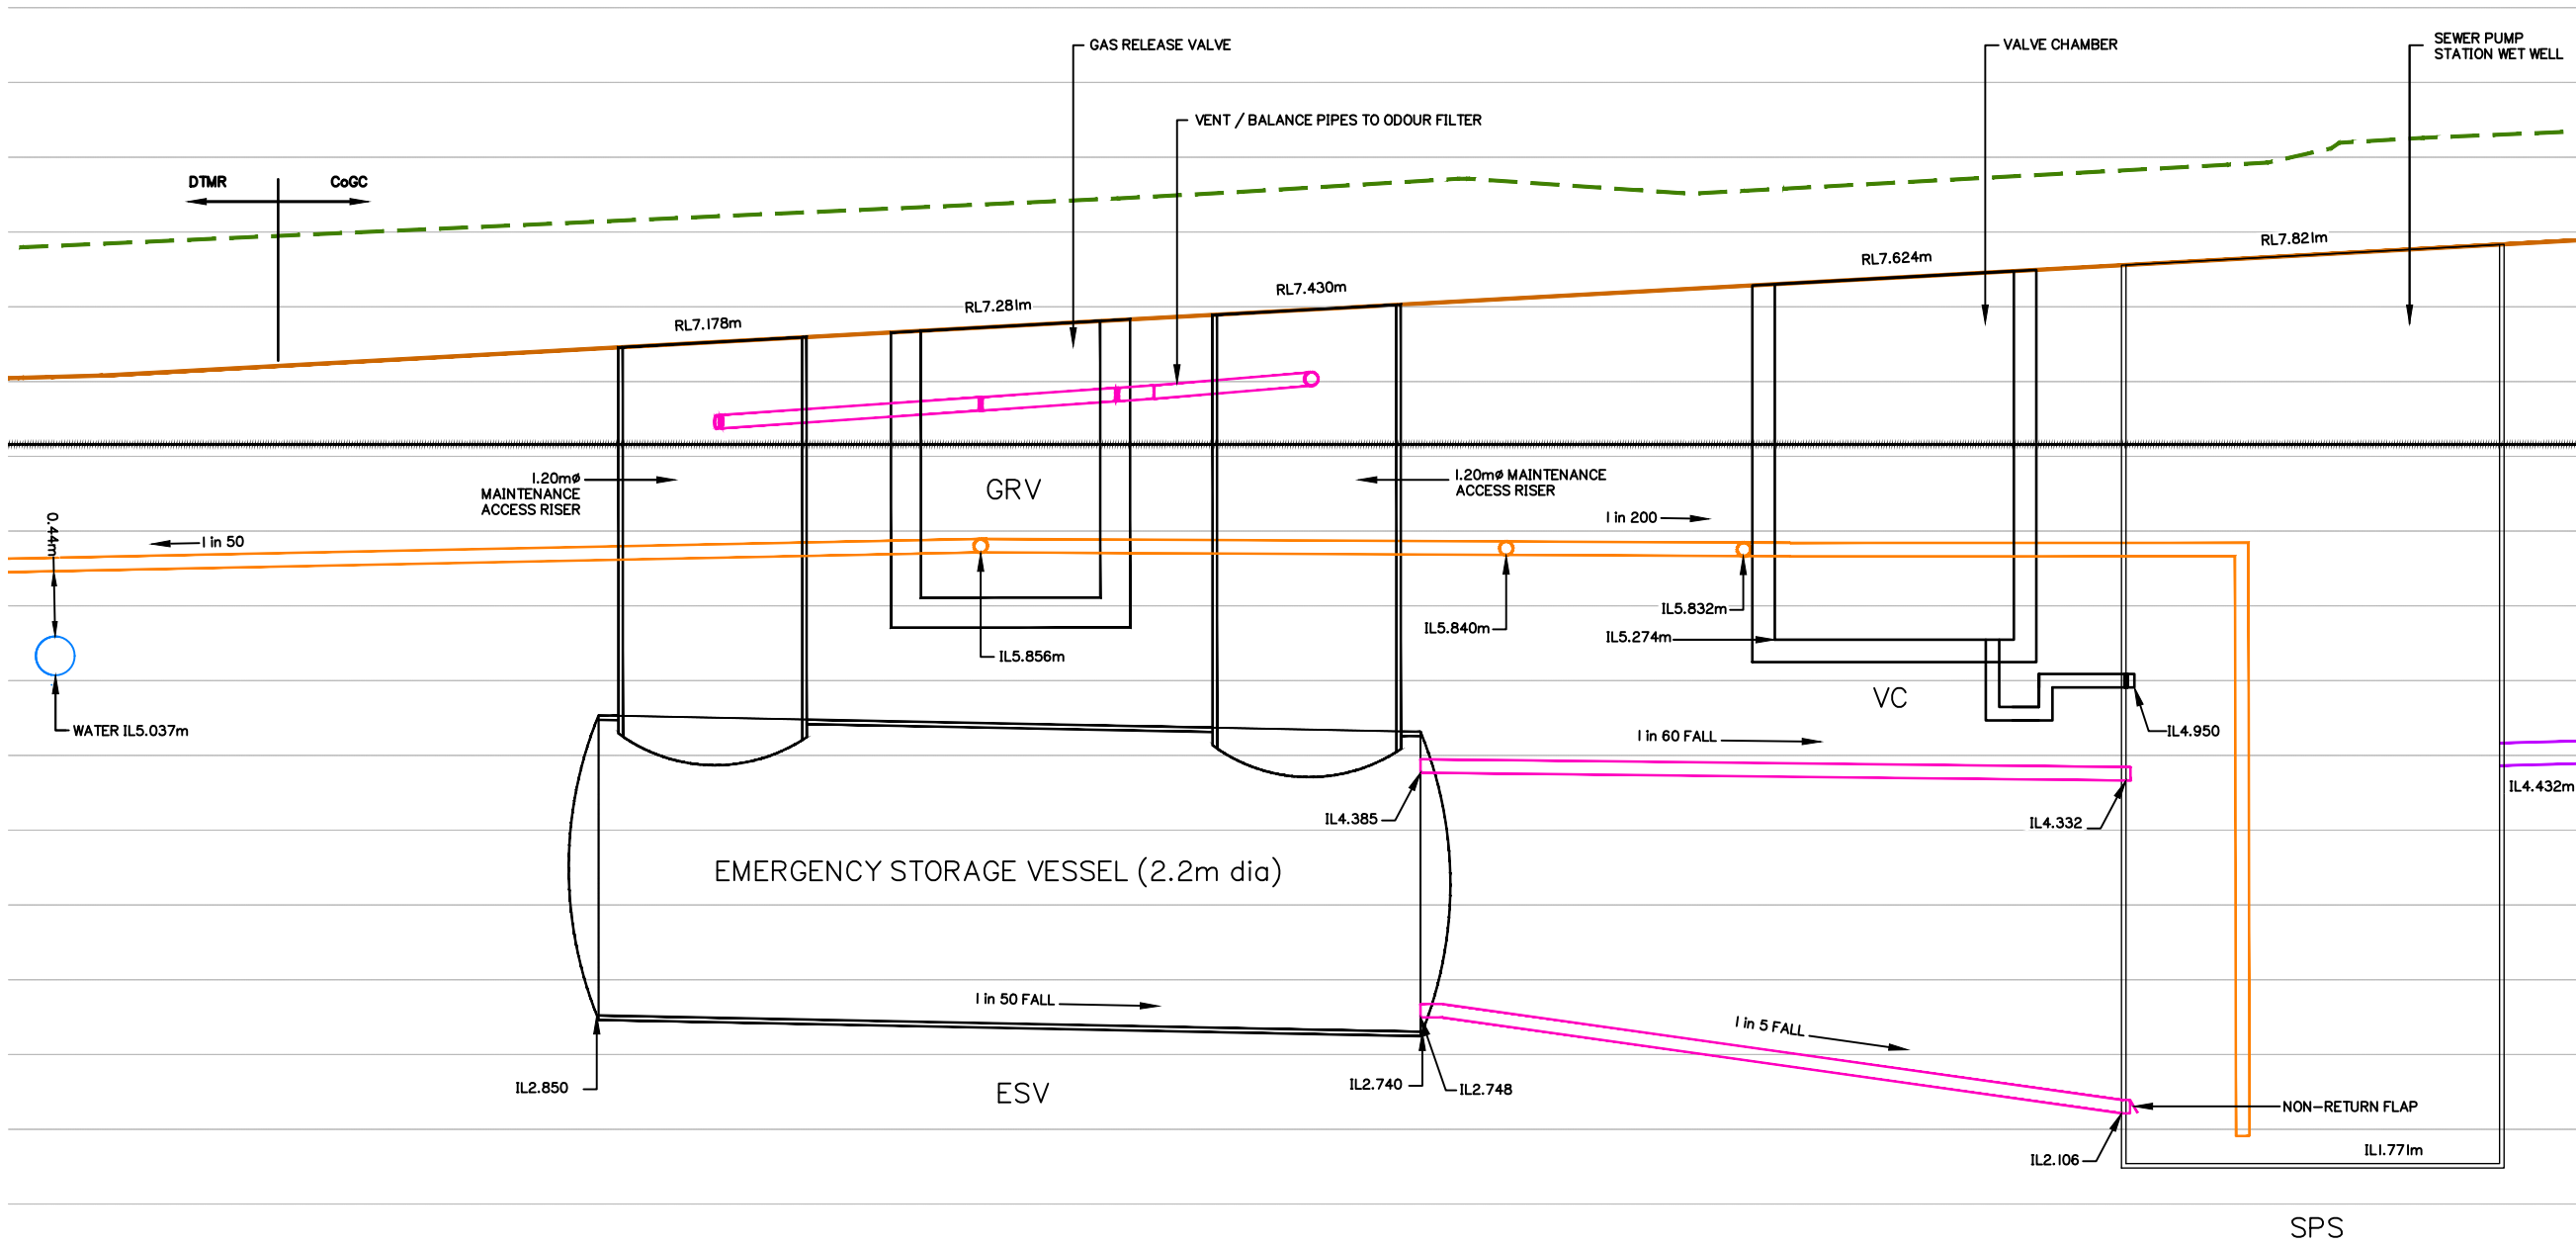

Client:



FRASERS PROPERTY
(AUSTRALIA) PTY. LTD.

Project:

VANTAGE YATALA STAGE 1

Site Address:

60 STAPYLTON JACOBS WELL
ROAD, STAPYLTON QLD 4207

THIS DRAWING IS INTENDED TO
BE PRINTED IN COLOUR

RPD:

Lot: 501
Plan: SP295994
Local Authority: CITY OF GOLD COAST
COUNCIL
Level Datum: AHD
Meridian: -
Contour Interval: -
PSM: -
RL: -

ISSUED FOR APPROVAL
NOT FOR CONSTRUCTION

©2012 Gassman Development Perspectives
All rights reserved. No part of this document may be reproduced or transmitted in any form or by any means, electronic, mechanical, photocopying, recording, or otherwise, without the written permission of Gassman Development Perspectives.


ALL DRAWINGS ARE TO BE READ IN CONJUNCTION WITH GENERAL NOTES

DRAWING TITLE

SEWER PUMP STATION
SYSTEM LONGITUDINAL
SECTION SHEET 3 OF 3

A	09-09-2021	ORIGINAL ISSUE	LAB	MG	
Issue	Date	Description	DRN	CHK	

 
SCALE IN METRES




Scale at A1: 1:25

Designed:	IG
Drafted:	LAB
Approved:	MG
RPEQ:	16939
Signed:	
Date:	09-09-2021

Drawing No:	Rev. No:
5941 ENG OPW1 651	A

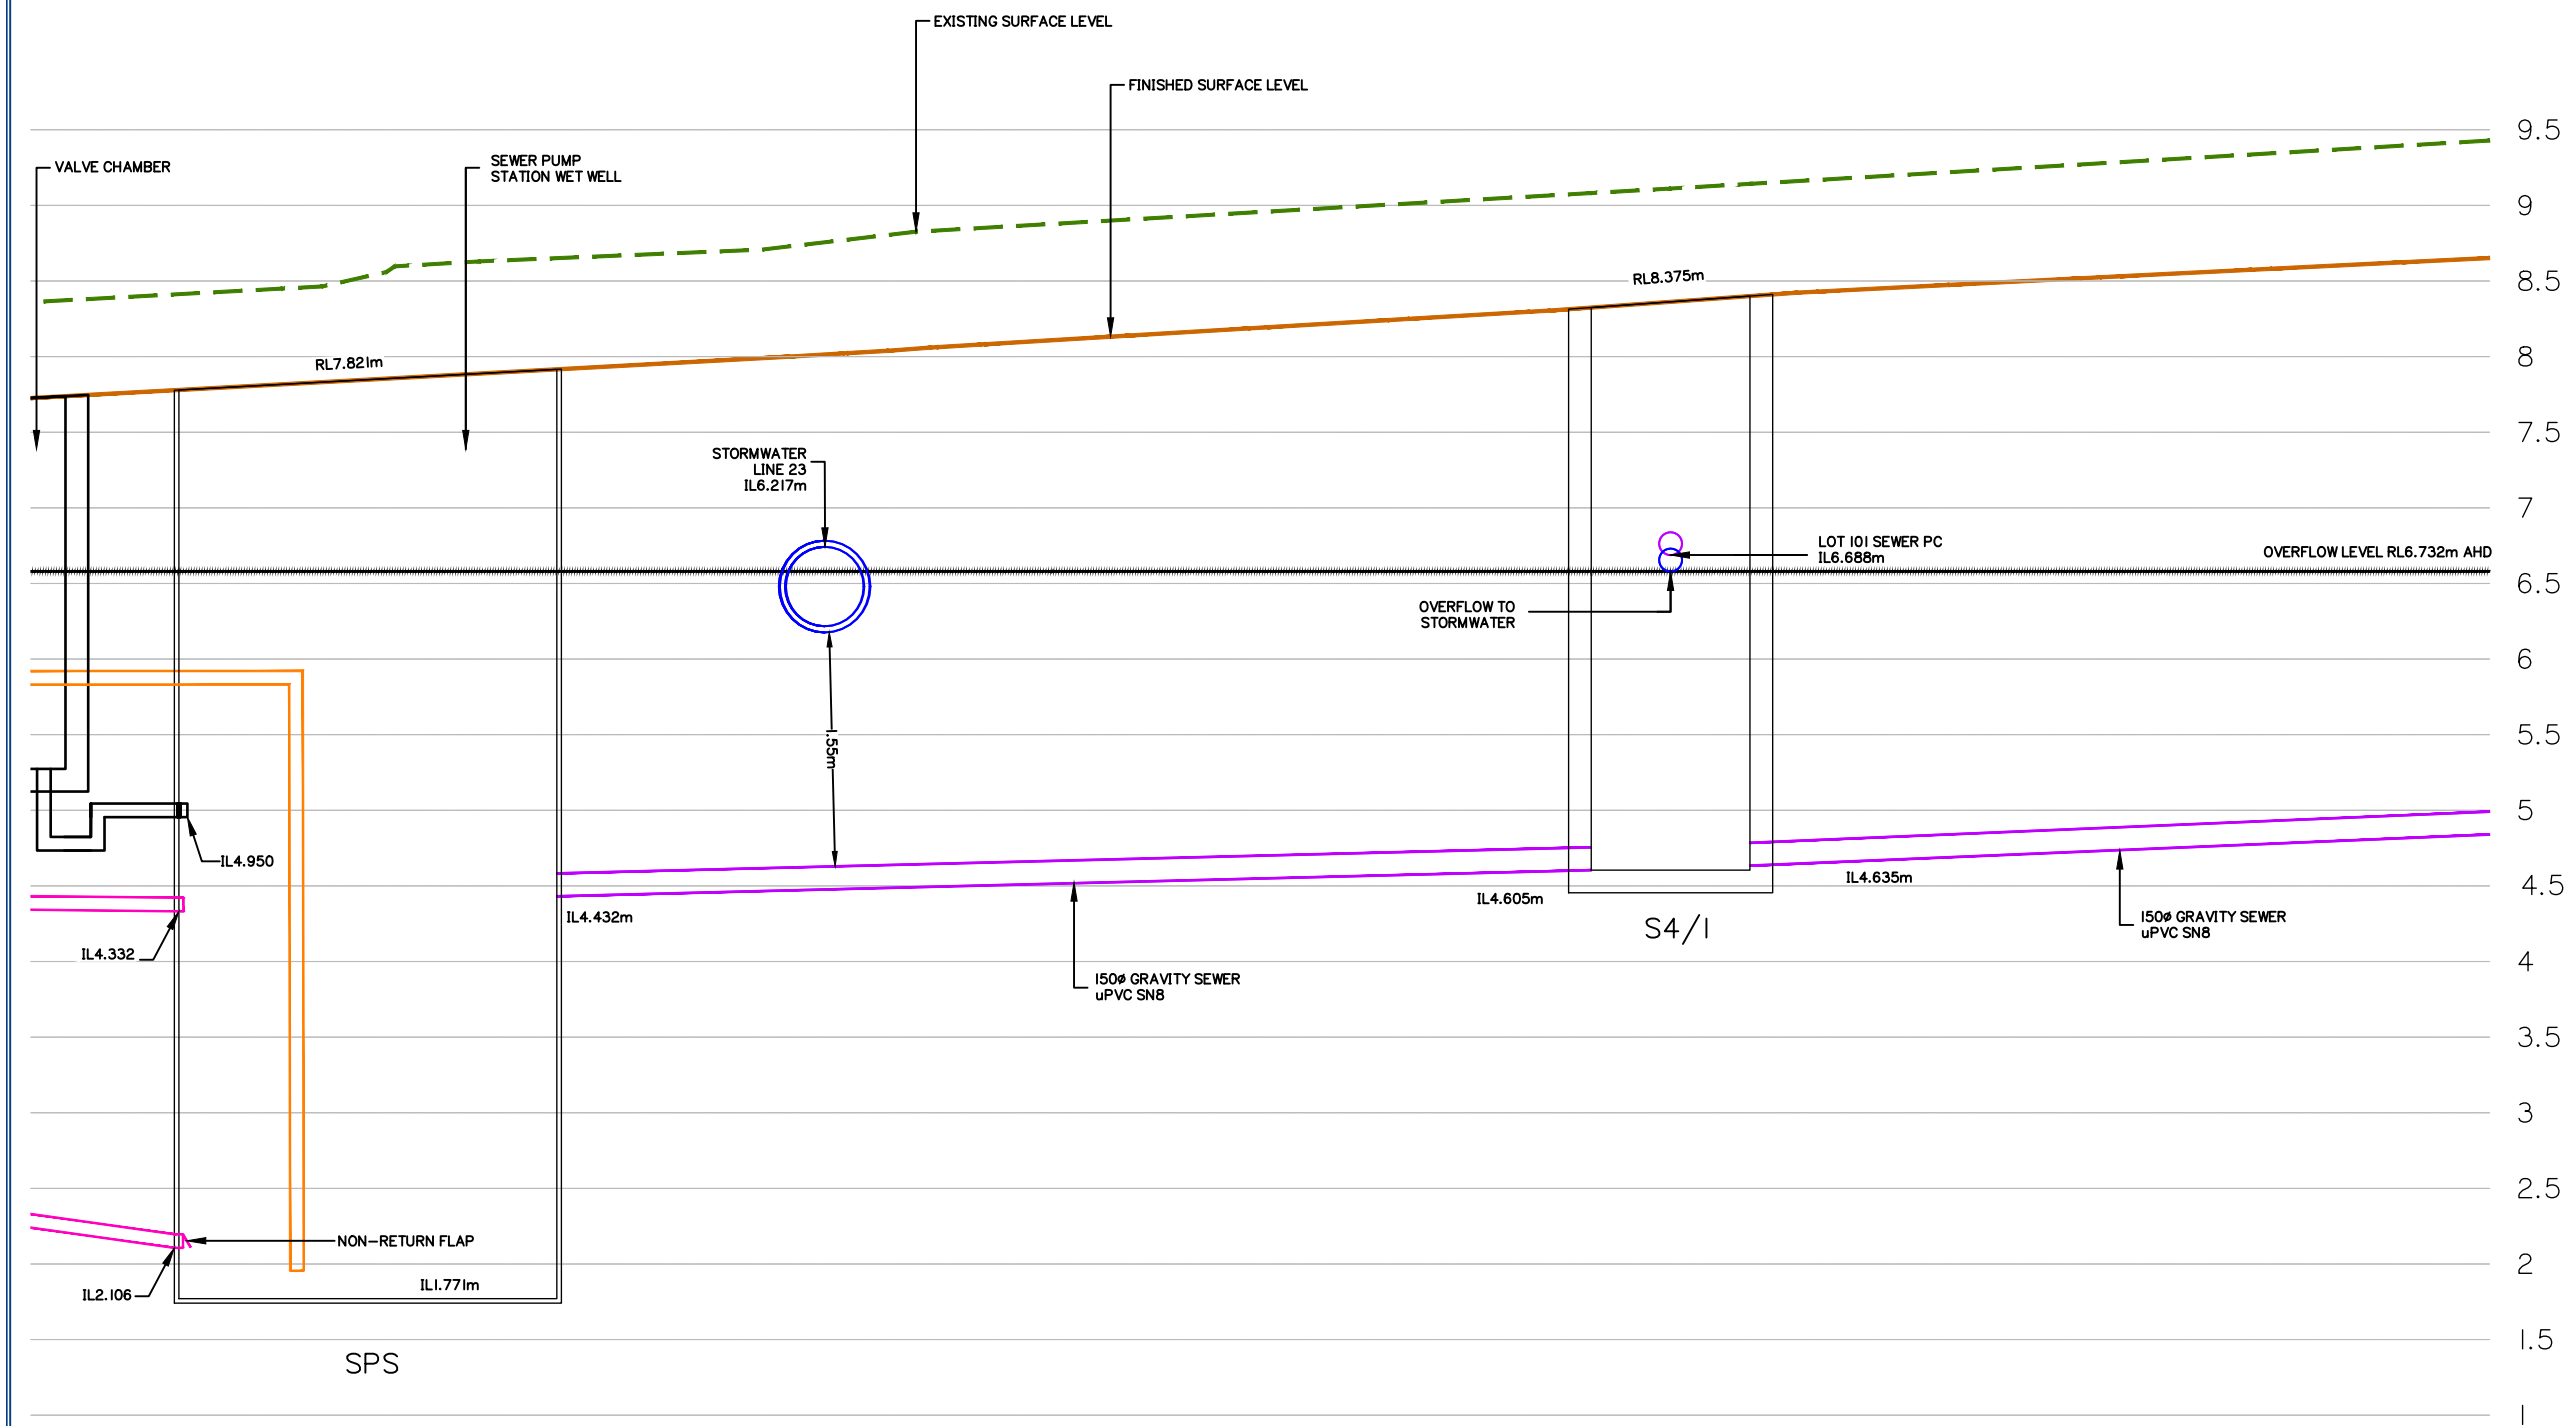

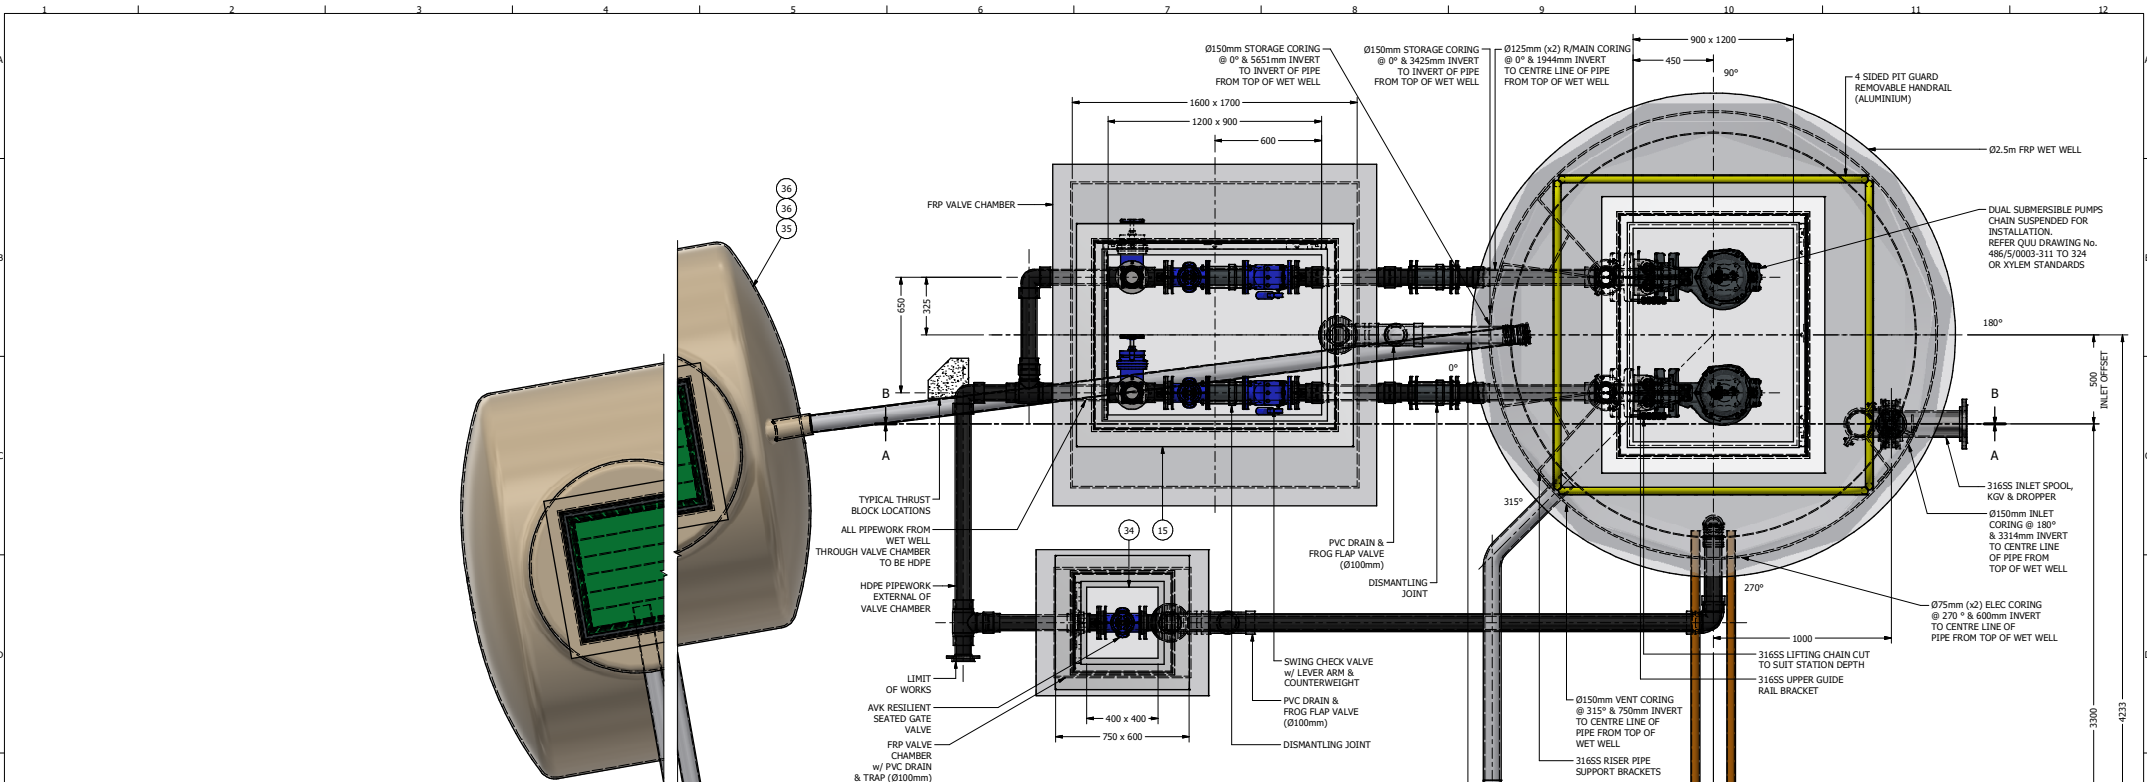

44	11-PUN	DN100 FLAP VALVE	PVC	1
43	11-PUN	UPPER OVERFLOW PIPE	PVC	1
42	11-PUN	LOWER OVERFLOW PIPE	PVC	1
41	11-PUN	50mm ELEC CONDUIT 2	PVC	1
40	11-PUN	50mm ELEC CONDUIT 1	PVC	1
39	11-PUN	SWITCHBOARD CONC FOUNDATION	CONC	1
38	11-PUN	CONCRETE FOUNDATION FOR V/PITS	CONC	1
37	11-PUN	4 SIDED PIT GUARD, REMOVABLE HANDRAIL	ALUM	1
36	11-PUN	CLASS D GATIC ACCESS LID (TRAFFICABLE), 0.6m x 0.6m	D/IRON	2
35	11-PUN	STORAGE TANK	HDPE	1
34	11-PUN	VALVE CHAMBER ACCESS LID w/OUT SAFETY GRATES	ALUM	1
33	11-PUN	DRAIN LINE ASSEMBLY 2	PVC	1
32	11-PUN	0.6m x 0.75m x 2.35m DEEP VALVE CHAMBER, FRP	GFRP	1
31	11-PUN	COLOUR FILTER ASSEMBLY - GH 375	FRP	1
30	11-PUN	CONCRETE FOUNDATION	CONC	1
29	11-PUN	DRAIN LINE ASSEMBLY	PVC	1
28	11-SUN	CAMLOCK FITTING FOR BYPASS PUMP CONNECTION	316SS	2
27	11-SUN	DN100 THRUST TYPE DISMANTLING JOINT	D/IRON	4
26	11-PUN	RP2D ASSY	316SS	1
25	11-PUN	RP2D COVER BOX ASSEMBLY	316SS	1
24	11-PUN	DROPPER TEE SUPPORT BRACKET	316SS	1
23	11-490176	Ø150mm COVER FOR KGV SPINDLE ACCESS	C/IRON	1
22	11-PUN	VALVE SUPPORT BRACKET	316SS	2
21	11-PUN	KGV EXTENDED SPINDLE UP TO 6m	316SS	1
20	11-PUN	CAP FOR KGV SPINDLE, VZ031602817	316SS	1
19	11-490355	DN150 UNIDIRECTIONAL KNIFE GATE VALVE w/ EXTENDED SPINDLE & KEY CAP	316SS	1
18	11-SUN	DN150 INLET TEE w/ DROPPER PIPE	316SS	1
17	11-490363	DN150 FLANGED INLET PIPE w/ WALL MOUNT BRACKET	316SS	1
16	11-PUN	VALVE SUPPORT BRACKET ASSY	316SS	5
15	11-PUN	VALVE CHAMBER ACCESS LID w/ FALL ARREST SAFETY GRATE	ALUM	1
14	11-PUN	WET WELL ACCESS LID w/ OUT SAFETY GRATES	ALUM	1
13	11-PUN	SWITCHBOARD (TBA)	MILD STEEL	1
12	11-PUN	100mm PVC PIPE, VENT PIPE	PVC	1
11	11-PUN	RIISING MAIN SUPPORT BRACKET	316SS	2
10	11-PUN	DN90 HDPE RISING MAIN w/ TABLE D FLANGES & 316SS BACKING RINGS	HDPE	1
9	11-PUN	DN80 SWING CHECK VALVE w/ LEVER & COUNTERWEIGHT & TABLE D DRILLING	D/IRON	2
8	11-PUN	DN100 AVK RESILIENT SEATED GATE VALVE, TABLE D, 57/98 SERIES C/W, H/W	D/IRON	5
7	11-SUN	LIFTING CHAIN w/ SHACKLE KIT TO SUIT STATION DEPTH	316SS	2
6	11-PUN	UPPER GUIDE RAIL BRACKET	316SS	2
5	11-PUN	GUIDE RAIL SCH40 6.1m LENGTH CUT TO SUIT, LOWER	316SS	4
4	11-PUN	FLYGT NP3127.161, SH247, 7.4kW SUBMERSIBLE PUMPS	D/IRON	2
3	4446803	FLYGT 80x80 DISCHARGE PEDASTAL w/ TABLE D DRILLING	C/IRON	2
2	11-PUN	1.7m x 1.6m x 2.2m DEEP VALVE CHAMBER, FRP	GFRP	1
1	11-PUN	Ø2.5m x 6.0m DEEP FRP WET WELL w/ 1.5m x 1.5m 2.2m DEEP INTEGRATED V/CHAMBER	GFRP	1
ITEM	PART NO.	DESCRIPTION	MATERIAL	QTY
PARTS LIST				

4	18/11/2021	AMENDED AS PER REVIEW	BC	GL	GL
3	4/12/2021	STORAGE TANK PIPING ADDED, ELEC CAB. RELOCATED	BC	GL	GL
2	27/10/2021	STORAGE TANK ADDED	BC	GL	GL
1	7/10/2021	V/CHAMB ADDED - ISSUED FOR MANUFACTURE	BC	PT	PT
0	3/06/2021	ISSUED FOR MANUFACTURE	BC	JP	JP
B	13/04/2021	AMENDED TO MEET GCC COMPLIANCE	BC	JP	JP
A	4/03/2021	GENERAL ARRANGEMENT	BC	JP	JP
REV	DATE	DESCRIPTION	BY	CHK	APP
REVISION HISTORY					

NOTE:
CONNECTING PIPE WORK FOR STORAGE TANK SUPPLIED BY OTHERS

CONCRETE TO BE DESIGNED IN ACCORDANCE WITH GCC SPECIFICATION (SCC40)

RP2D w/ STANDARD FIXINGS AND STAINLESS STEEL COVER BOX
NOTE: RP2D UNIT BY OTHERS REFER TO PROJECT DOCUMENTATION FOR SITE LOCATION

STANDARD COGC SWITCHBOARD (0.415) (1.7 x 0.5 x 2.025m HG)
NOTE: CONTROL PANEL TO BE CONFIRMED ON COMPLETION OF ELECTRICAL DESIGN DOCUMENTATION

PLAN VIEW - PUMP STATION
SCALE (DNS)

PUMP WEIGHT (kg)	
PUMP	147kg
DISCHARGE	35kg

COPYRIGHT
THIS DRAWING AND DESIGN IS SUPPLIED BY XYLEM IS COVERED BY COPYRIGHT AND IS NOT TO BE REPRODUCED OR IN ANY WAY COPIED TO ANY THIRD PARTY WITHOUT THE WRITTEN CONSENT OF XYLEM.

CONFIDENTIAL INFORMATION
THIS DRAWING AND DESIGN IS SUPPLIED AS CONFIDENTIAL INFORMATION AS SPECIFIED IN THE CONTRACT OR AS CONFIDENTIAL INFORMATION AS DEFINED IN XYLEM TERMS AND CONDITIONS OF COMPONENT SALES.

xylem
Let's Solve Water
XYLEM WATER SOLUTIONS
UNIT 2, 2 CARPINE DRIVE
EASTON OCEAK
SYDNEY, 2766
PH: +61 2 9832 6000
FX: +2 9832 6483

ALSO ADELAIDE, BRISBANE, DARWIN, KALGOORLIE, MARRATHA, MELBOURNE, MACKAY, MT ISA, NEWCASTLE, ORANGE, SYDNEY, TOWNSVILLE, TASMANIA & AGENTS

LINKED TOLERANCES EXCEPT WHERE OTHERWISE SPECIFIED:
UP TO 250mm: 0.25mm
250mm TO 500mm: 0.30mm
500mm TO 1000mm: 0.40mm
1000mm TO 2000mm: 0.50mm
2000mm AND OVER: 0.60mm
HOLE CENTRES: 0.25mm
DIMENSIONED HOLES: 0.25mm

LENGTH OF SUBMERSED PIPE:
UP TO 100mm: 4.10°
101mm AND OVER: 4.10°

CLIENT: GASSMAN CONSULTANTS
PROJECT: VANTAGE YATALA - JACOBS WELL
TITLE: 11-FRP2560-90DESS w/ FLYGT NP3127.161-SH247, 7.4kW SUBMERSIBLE PUMPS
PLAN VIEW

CONTRACT / REFERENCE No.: TBA
DRAWN: BC
CHECKED: JP
DATE: 4.3.2021
APPROVED: JP
SHEET: 2 of 4
SCALE: 1:12
DWG NO: FA8368-01
SHT SIZE: REV: 4



DATUM RL = 0.700				
PIPE INVERT LEVEL				
EXISTING SURFACE LEVEL				
FINISHED SURFACE LEVEL				
COVER TO PIPE				
DEPTH TO PIPE INVERT				
PIPE CHAINAGE				
0	-2.011	1.752	7.048	5.037
4	-2.144	1.964	7.193	5.049
5	-2.191	2.011	7.243	5.052
5.262	-2.205	2.025	7.258	5.053
5.716	-2.232	2.052	7.286	5.054
10	-1.422	1.242	7.599	6.178
12.464	-0.950	0.777	7.774	6.824
13.662	-0.954	0.774	7.854	6.900
15	-0.961	0.761	7.946	6.985
20	-0.955	0.775	8.256	7.301
21.281	-0.952	0.772	8.333	7.381

LONGITUDINAL SECTION – DESIGN WATER

AI HORZ SCALE: 1 : 400
AI VERT SCALE: 1 : 40

No	DESCRIPTION	DIA MAIN	FSL	ESL	IL	DEPTH TO INVERT (FSL)	DEPTH TO INVERT (ESL)
I(A)	CONTRACTOR TO ENSURE SLUICE VALVE OFF 150mm DIA EXTERNAL WATER MAIN IS CLOSED						
I(B)	CONTRACTOR TO CONSTRUCT NEW 150mm DIA LINE OFF EXISTING 150mm ISOLATED LINE	150mm DICI	7.193m	8.117m	5.049m	2.144m	3.068m
I(C)	SLUICE VALVE SHALL REMAIN CLOSED UNTIL AFTER SUCCESSFUL "ON MAINTENANCE INSPECTION" NOTE: ALL WORKS TO BE CARRIED OUT UNDER GCWW SUPERVISION AND AT DEVELOPER'S EXPENSE						

WATER FITTING SCHEDULE	
No	DESCRIPTION
1	FIRE HYDRANT
2	DICL BEND 90°
3	DICL BEND 22.5°
4	DICL BEND 11.25°
5	SLUICE VALVE
6	DICL 150x150 TEE
7	END CAP
8	150x150 TEE WITH BLANK FLANGES
9	DICL BEND 6°



**gassman
development
perspectives**
est 1985

planning | environment | landscape | engineering | survey

3807 3333 | F: 3287 5461 | www.gassman.com.au

Gold Coast & Logan | 76 Business Street, Yatala QLD | PO Box 392, Beerleigh 4207

Client:



Project:

VANTAGE YATALA STAGE 1

Site Address:

60 STAPYLTON JACOBS WELL
ROAD, STAPYLTON QLD 4207

THIS DRAWING IS INTENDED TO
BE PRINTED IN COLOUR

RPD:

Lot:	501
Plan:	SP295994
Local Authority:	CITY OF GOLD COAST COUNCIL
Level Datum:	AHD
Meridian:	-
Contour Interval:	-
PSM:	-
RL:	-

ISSUED FOR APPROVAL
NOT FOR CONSTRUCTION

© 2012 Gassman Development Perspectives
All rights reserved. No part of this document may be reproduced or transmitted in any form or by any means, electronic, mechanical, photocopying, recording, or otherwise, without the written permission of Gassman Development Perspectives.

ALL DRAWINGS ARE TO BE READ IN CONJUNCTION WITH GENERAL NOTES

DRAWING TITLE

WATER RETICULATION
LAYOUT PLAN SHEET 1 OF 4

G	09-09-2021	DICL WM BENDS AMENDED ON EASTRIDGE STREET	LAB	MG					
F	01-08-2021	DICL WM BENDS AMENDED ON EASTRIDGE STREET	IG	MG					
E	30-04-2021	RESPONSE TO COUNCIL INFORMATION REQUEST	IG	MG					
D	12-03-2021	MINOR CHANGE	BA	MG					
C	28-10-2020	ISSUED FOR CONSTRUCTION	BA	MG					
C	02-09-2020	MINOR CHANGE TO STAGE 1	BA	MG					
B	12-06-2020	INFORMATION REQUEST RESPONSE	BA	MG					
A	01-05-2020	ORIGINAL ISSUE	BA	MG					
Issue	Date	Description	DRN	CHK					

SCALE IN METRES



Scale at A1:	1:500
--------------	-------

Designed:	IG
Drafted:	BA
Approved:	MG
RPEQ:	16939
Signed:	
Date:	09-09-2021

Drawing No:	Rev. No:
5941 ENG OPW1 700	G