

g a s s m a n **development perspectives**

T: 07 3807 3333 | F: 07 3287 5461 | www.gassman.com.au
76 Business Street, Yatala QLD | PO Box 392, Beenleigh 4207

Attention: **Development Assessment**

Job No: 6098

All revisions supersede any revision of the same document.

[illegible]

☐ Our Mess. ☐ Courier ☐ Email
☐ Your Mess. ☐ Mail ☐ Aconex
☐ Hand ☐ FTP Site ☒

Issued for: _____

Issued Media

Drg/Doc No.

Title

Revision Issued


Please confirm that you have received all documents listed on the Document Register & Transmittal.

I hereby acknowledge receipt of the documents listed above.

Name & Company: _____ Signed: _____ Dated: / /


Project Manager: Mitchell Gassman - mgassman@gasmman.com.au

Sent by: Mitchell Gassman - mgassman@gasmman.com.au

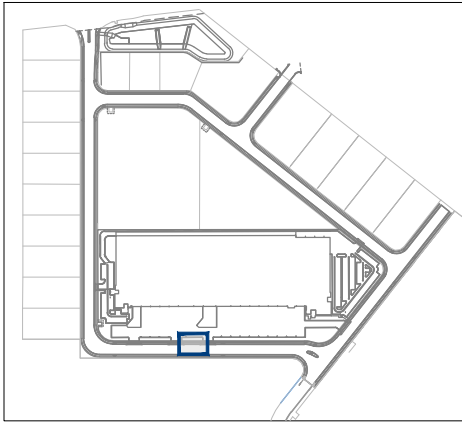

KEY PLAN
SCALE 1: 7500


ON LOT WATER METER WORKS LIVE WORKS SCHEDULE – WATER					
No.	DESCRIPTION	DIA. MAIN	ESL	IL	DEPTH TO INVERT (ESL)
1(A)	ISOLATE EXISTING 150MM DIAMETER POTABLE WATERMAIN. REMOVE EXISTING END CAP OFF DICL TEE AND CONNECT LEAD IN FOR METER ASSEMBLY.	150	19.000	17.773	1.227

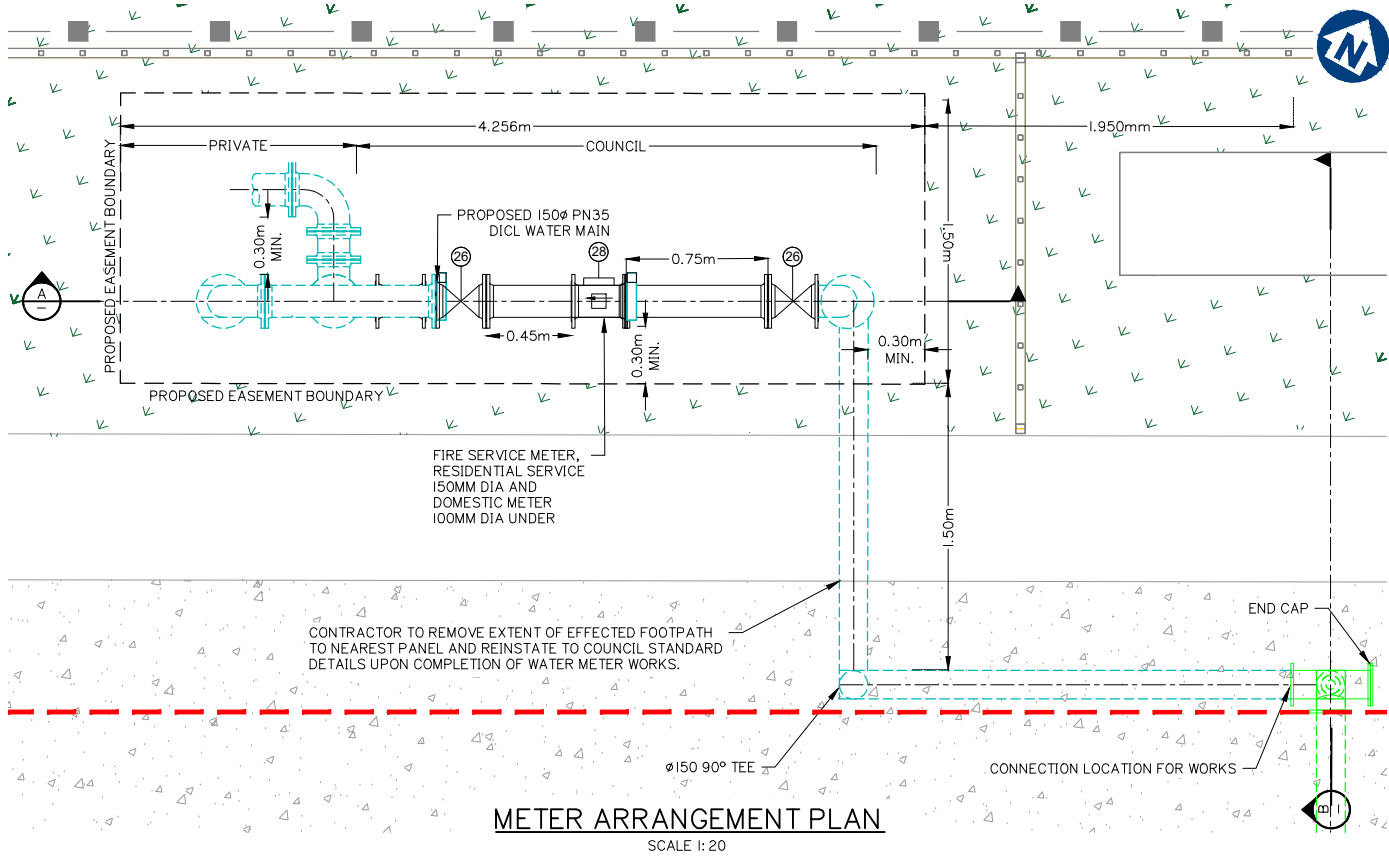


METER ARRANGEMENT PLAN
SCALE 1: 20

WATER FITTING SCHEDULE	
No	DESCRIPTION
4	DN150 RESIDENTIAL WATER METER
21	DN150 DIRT BOX/STRAINER
23	DN150 DICL PN35 PIPE
26	DN150 RESILIENT SEATED GATE VALVE
27	DN150 BLANK FLANGE
28	DN150 ELECTRO-MAG FLOW METER
47	DN150 TEST PORT


NOTE:
CONTRACTOR TO CONFIRM LOCATIONS AND LEVELS OF EXISTING SERVICES PRIOR TO COMMENCEMENT OF WORKS AND NOTIFY SUPERINTENDENT IF DIFFERENT FROM THOSE SHOWN.

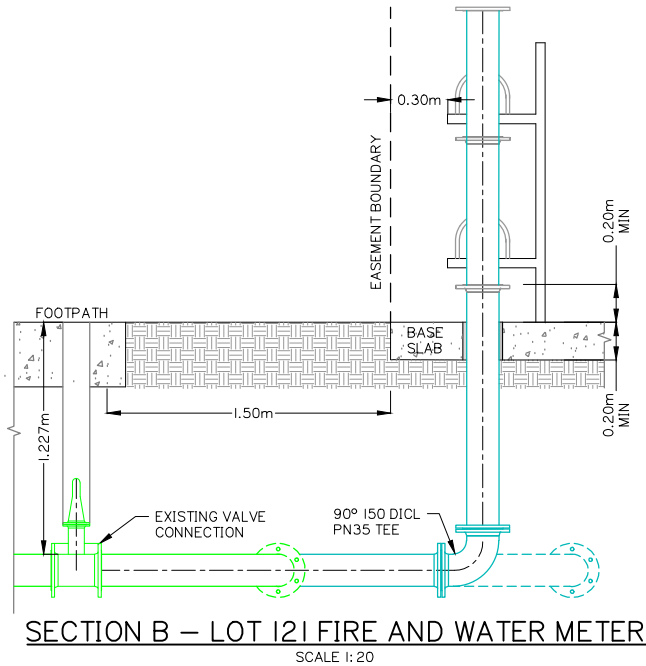

SECTION B – LOT 121 FIRE AND WATER METER
SCALE 1: 20

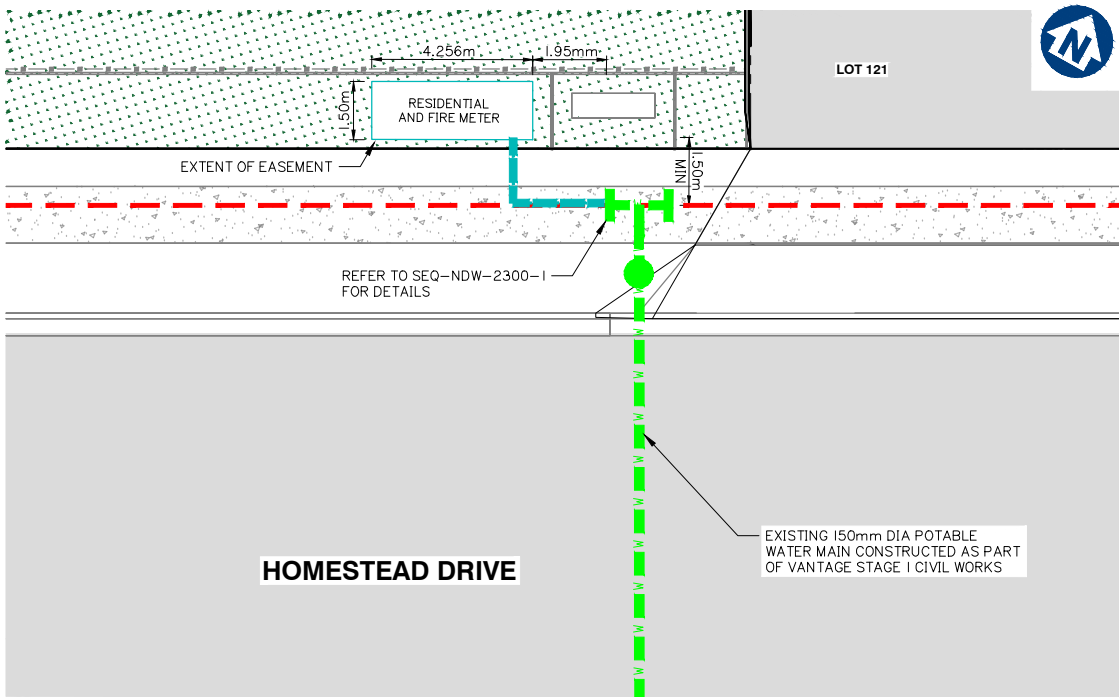

TYPICAL WATER METER ARRANGEMENT PLAN
SCALE 1: 100

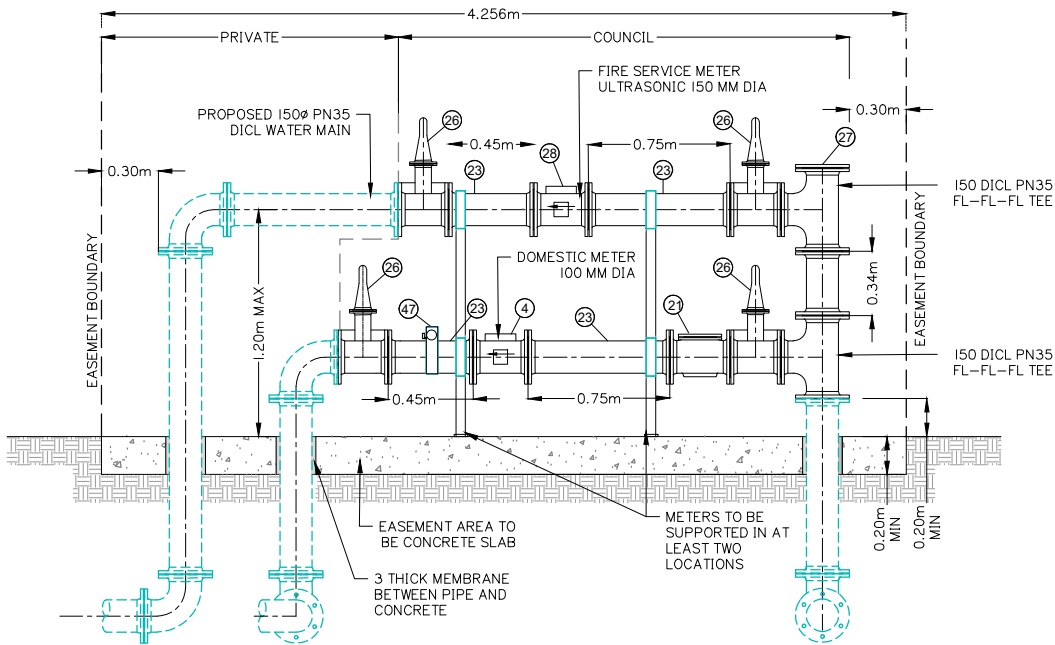

SECTION A – LOT 121 FIRE AND WATER METER
SCALE 1: 20

ROADWORKS AND DRAINAGE LAYOUT PLAN AND DETAILS

Client:

HCA QUEENSLAND PTY. LTD.

Project:
LOT 121 POTABLE AND FIRE WATER
METER ASSEMBLY

Site Address:
HOMESTEAD DRIVE,
STAPYLTON QLD 4207

THIS DRAWING IS INTENDED TO
BE PRINTED IN COLOUR

RPD:
Lot: 120 - 122
Plan: SP316168
Local Authority: CITY OF GOLD COAST
COUNCIL
Level Datum: AHD
Meridian: -
Contour Interval: -
PSM: -
RL: -

ISSUED FOR APPROVAL
NOT FOR CONSTRUCTION

© 2012 Gassman Development Perspectives
All rights reserved. No part of this document may be reproduced or transmitted in any form or by any means, electronic, mechanical, photocopying, recording, or otherwise, without the written permission of Gassman Development Perspectives.

ALL DRAWINGS ARE TO BE READ IN CONJUNCTION WITH GENERAL NOTES

DRAWING TITLE
WATER METER PLAN
AND DETAIL

Issue	Date	Original Issue Description	JH	MG
A	02-09-2022	ORIGINAL ISSUE	JH	MG

Scale at A1: 1:100
Designed: JH
Drafted: TGP
Approved: MG
RPEQ: 16939
Signed:
Date: 02-09-2022

Drawing No: 6098 ENG OPW 001
Rev. No: A